

Annexure 2

Development Plans

PROPOSED MIXED USE DEVELOPMENT - BROOKLYN ON MAIN

10 MORLEY DRIVE, TUART HILL, WA 6060

DEVELOPMENT APPLICATION



SHEET LIST			
SHEET NO.	SHEET NAME	REV.	REV. DATE
DA0000	COVER SHEET WITH DRAWING LIST	A	25/03/2021
DA0002	SURVEY PLAN	A	25/03/2021
DA0010	SITE PLAN	A	25/03/2021
DA0500	DEMOLITION PLAN	A	25/03/2021
DA1000	BASEMENT PLAN	A	25/03/2021
DA1001	GROUND FLOOR PLAN	A	25/03/2021
DA1002	LEVEL 01 PLAN	A	25/03/2021
DA1003	LEVEL 02 PLAN	A	25/03/2021
DA1004	LEVEL 03 PLAN	A	25/03/2021
DA1005	LEVEL 04 PLAN	A	25/03/2021
DA1006	LEVEL 05 PLAN	A	25/03/2021
DA1007	ROOF PLAN	A	25/03/2021
DA2000	ELEVATION 01	A	25/03/2021
DA2001	ELEVATION 02	A	25/03/2021
DA2002	ELEVATION 03	A	25/03/2021
DA2003	ELEVATION 04		
DA2004	ELEVATION 05	A	25/03/2021
DA2005	ELEVATION 06	A	25/03/2021
DA2500	SECTION 01	A	25/03/2021
DA2501	SECTION 02	A	25/03/2021
DA2502	SECTION 03	A	25/03/2021
DA2503	SECTION 04	A	25/03/2021
DA4000	SHADOW DIAGRAM 01 - JUNE 21	A	25/03/2021
DA4001	SHADOW DIAGRAM 02 - AUG 22	A	25/03/2021
DA4002	SHADOW DIAGRAM 03 - SEPT 22	A	25/03/2021
DA4003	SHADOW DIAGRAM 04 - OCT 22	A	25/03/2021
DA4010	PLOT RATIO AREA 01	A	25/03/2021
DA4011	PLOT RATIO AREA 02	A	25/03/2021
DA4015	APARTMENT SCHEDULE	A	25/03/2021
DA4020	DAYLIGHT ACCESS	A	25/03/2021
DA4030	CROSS VENTILATION	A	25/03/2021
DA4040	VISUAL PRIVACY	A	25/03/2021
DA4050	EXISTING STREET CONTEXT	A	25/03/2021
DA4051	STREET CONTEXT	A	25/03/2021
DA4060	ARCHITECTURAL VIGNETTES	A	25/03/2021
DA4070	EXTERNAL RENDER	A	25/03/2021
DA4071	INTERNAL RENDER	A	25/03/2021
TOTAL: 37			

©architectus™

Architectus Australia Pty Ltd is the owner of the copyright subsisting in these drawings, plans, designs and specifications. They must not be used, reproduced or copied, in whole or in part, nor may the information, ideas and concepts therein contained (which are confidential to Architectus Australia Pty Ltd) be disclosed to any person without the prior written consent of that company.

Nominated Architect
Ray Brown, NSWARB 6359

Do not scale drawings. Verify all dimensions on site

issue	amendment	date
A	DA SUBMISSION	25/03/2021

DEPARTMENT OF PLANNING, LANDS AND HERITAGE	
DATE	FILE
07-Apr-2021	SDAU-007-20

architectus™

Adelaide
Brisbane
Melbourne
Sydney
Perth

Architectus Perth
QV1 Upper Plaza West
250 St. Georges Terrace
Perth WA 6000
T (61 8) 9412 8355

perth@architectus.com.au
ABN 90 131 245 684

checked AS
drawn FMK
scale @A3

project	10 MORLEY DRIVE, TUART HILL
drawing	COVER SHEET WITH DRAWING LIST
project no	200611
drawing no.	DA0000
issue	A
26/03/2021 11:55:53 AM	

VISION SURVEYS CONSULTING

VISION SURVEYS CONSULTING VERIFIED THAT AN ALIGNMENT SURVEY HAS BEEN CONDUCTED ON 06/09/2018 TO ESTABLISH THE BOUNDARY POSITIONS OF LOT 16 ON PLAN 3038/2. THE POSITION OF ALL STRUCTURAL FEATURES REPRESENTED ON THIS PLAN ARE TO BE ASSUMED ACCURATE IN RELATION TO THE BOUNDARY. VISION SURVEYS CONSULTING IS NOT LIABLE FOR ANY CHANGES MADE TO THE PARCEL OR PORTION OF THE PARCEL OF LAND SHOWN ON THIS SURVEY INCLUDING BUT NOT LIMITED TO ANY ADJOINING PARCEL THAT HAVE OCCURRED AFTER THE DATE ON THIS SURVEY.

CLIENTS DETAILS:

Glenn Hitch

DWG REF: Morley 10 F - ROAD WIDENING

STREET NAME:

Morley Drive

LOT #:

16

HOUSE #:

10

SUBURB:

Tuart Hill

LOCAL AUTHORITY:

City of Stirling

LOT AREA:

3108m²

R CODE:

R30

SURVEY DATE:

06/09/2018

SCALE AT A3 SIZE:

1:400

LEGEND

WATER METER

SEWER AC

TEST STA PT

POWER POLE

POWER DOME

2/3 FLOOR WINDOW

TEMP BENCHMARK

VALVE

SEWER STATION

SEWER CONN.

ELECTRICAL BOX

TRAFFIC LIGHT

TIMBER/METAL POST

LIGHT POLE

GULLY

DRAINAGE PT

SIGN POLE

WATER METER

SEWER AC

TEST STA PT

POWER POLE

POWER DOME

2/3 FLOOR WINDOW

TEMP BENCHMARK

VALVE

SEWER STATION

SEWER CONN.

ELECTRICAL BOX

TRAFFIC LIGHT

TIMBER/METAL POST

LIGHT POLE

GULLY

DRAINAGE PT

SIGN POLE

Note: Calculated Area = 3114m²
Calculated Area after Rd Widening = 2956m²

project	10 MORLEY DRIVE, TUART HILL
drawing	
project no	200611
drawing no.	DA0002
issue	A
3/26/2021 12:22:50 PM	

architectus™

Architectus Perth

QV1 Upper Plaza West

250 St. Georges Terrace

Perth WA 6000

T (61 8) 9412 8355

perth@architectus.com.au

ABN 90 131 245 684

checked

drawn

scale

Checker

Author

@ A3

issue	amendment	date
A	DA SUBMISSION	25/03/2021


architectus™

Architectus Australia Pty Ltd is the owner of the copyright subsisting in these drawings, plans, designs and specifications. They must not be used, reproduced or copied, in whole or in part, nor may the information, ideas and concepts therein contained (which are confidential to Architectus Australia Pty Ltd) be disclosed to any person without the prior written consent of that company.

Nominated Architect

Ray Brown, NSWARB 6359

Do not scale drawings. Verify all dimensions on site

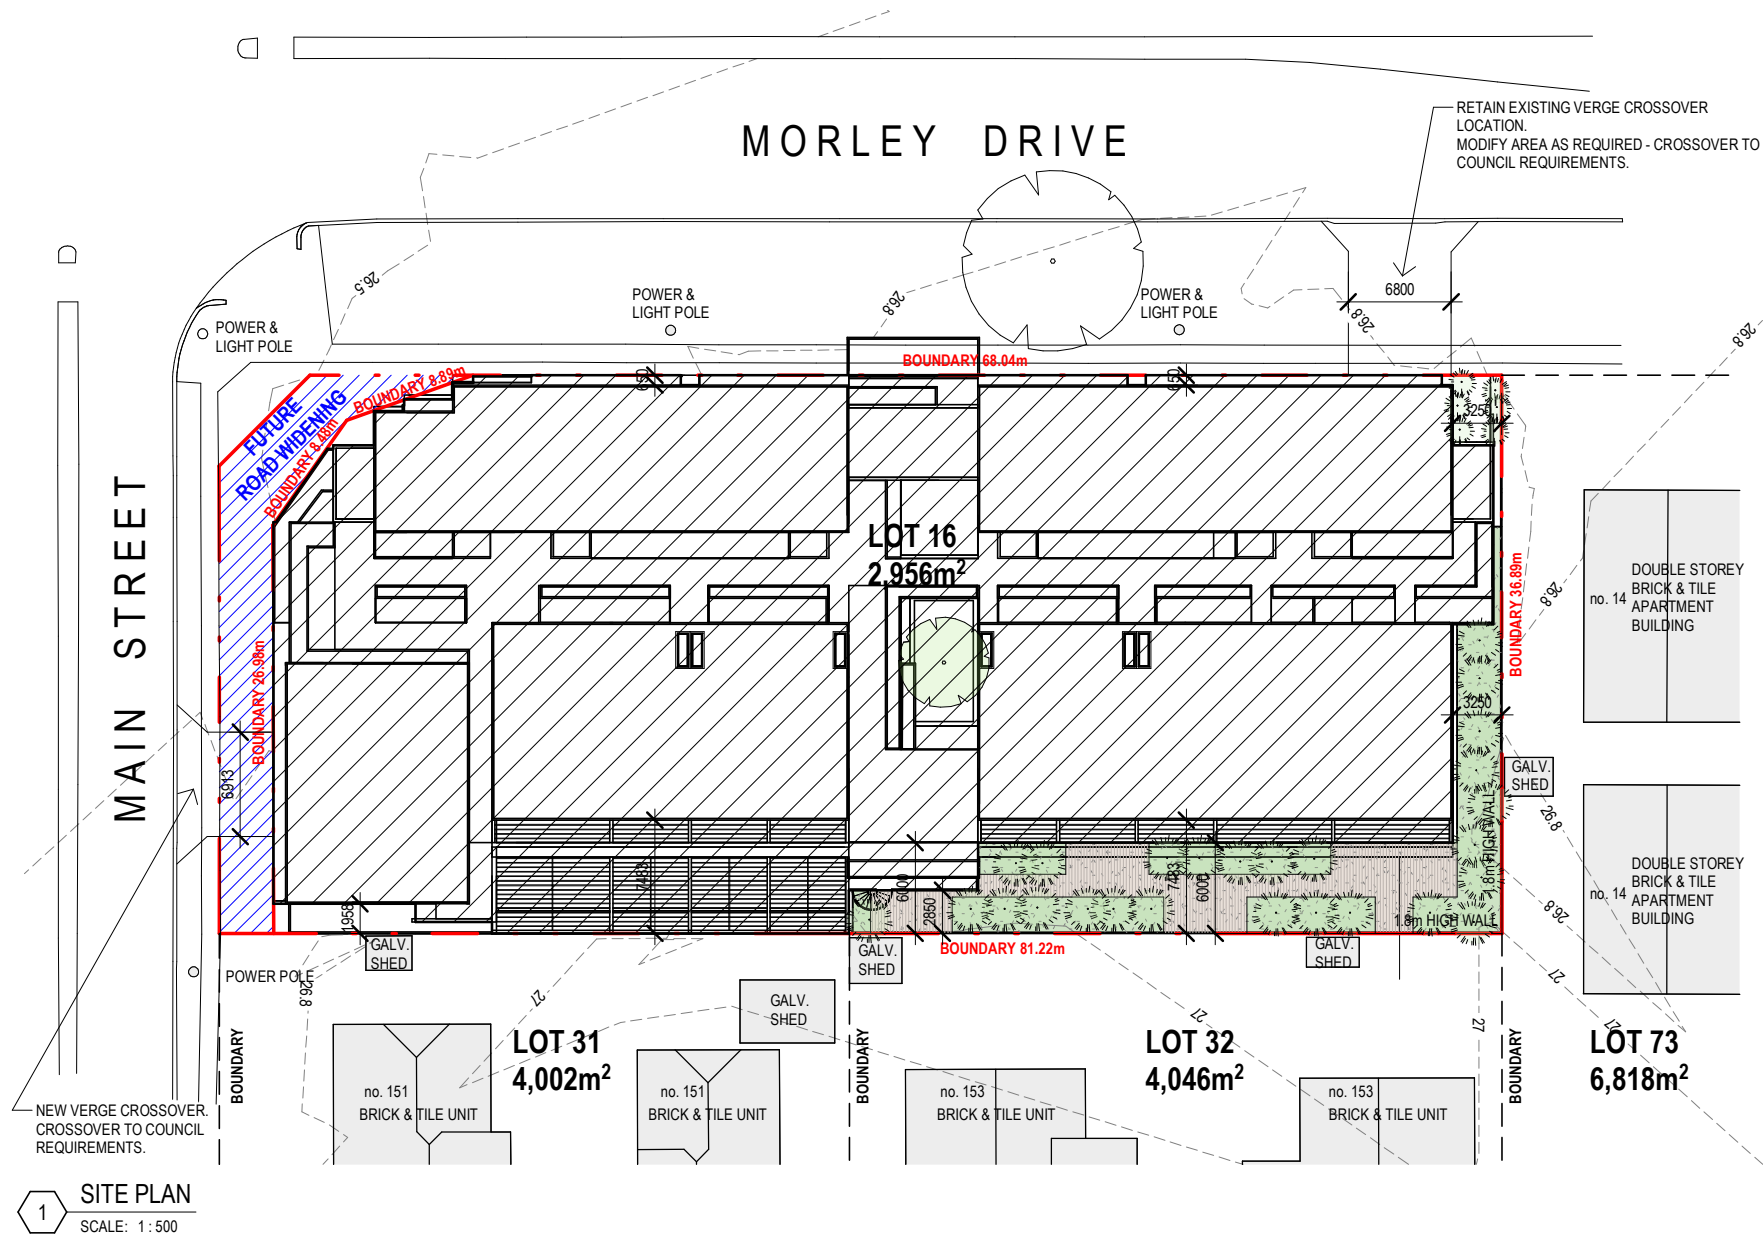

1 SITE PLAN
SCALE: 1:500

KEY	
LOCAL AUTHORITY:	CITY OF STIRLING
SITE AREA:	2,956m ²
LANDSCAPE AREA:	828m ²
DEEP SOIL AREA:	325m ²
APARTMENTS:	68
1 BED:	18
2 BED:	39
3 BED:	11
RESIDENTIAL PARKING	
RESIDENTIAL PARKING BAY:	68
SMALL CAR BAY:	4
ACCESSIBLE PARKING BAY:	4
VISITOR PARKING BAY:	10
TOTAL:	86
MOTORBIKE SPACE:	8
RESIDENTIAL BICYCLE SPACE:	34
VISITOR BICYCLE SPACE:	7

COMMERCIAL PARKING	
COMMERCIAL PARKING BAY	16
ACCESSIBLE PARKING BAY:	1
TOTAL:	17
COMMERCIAL BICYCLE SPACE	4
VISITOR BICYCLE SPACE:	1

SITE LEGEND	
	BOUNDARY LINE
	SITE BUILDING
	CONTEXT BUILDING
	FUTURE ROAD WIDENING


©architectus™

Architectus Australia Pty Ltd is the owner of the copyright subsisting in these drawings, plans, designs and specifications. They must not be used, reproduced or copied, in whole or in part, nor may the information, ideas and concepts therein contained (which are confidential to Architectus Australia Pty Ltd) be disclosed to any person without the prior written consent of that company.

Nominated Architect
Ray Brown, NSWARB 6359

Do not scale drawings. Verify all dimensions on site

issue	amendment	date
A	DA SUBMISSION	25/03/2021

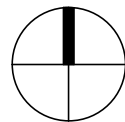

DEPARTMENT OF PLANNING, LANDS AND HERITAGE	
DATE	FILE
07-Apr-2021	SDAU-007-20

architectus™

Adelaide
Brisbane
Melbourne
Sydney
Perth

Architectus Perth
QV1 Upper Plaza West
250 St. Georges Terrace
Perth WA 6000
T (61 8) 9412 8355

perth@architectus.com.au
ABN 90 131 245 684

checked AS
drawn FMK
scale 1:250 @ A3

project 10 MORLEY DRIVE, TUART HILL


drawing SITE PLAN

project no 200611

drawing no. DA0010 A

26/03/2021 11:56:12 AM

DEMOLITION LEGEND	
	DEMOLISH DASHED RED LINES DENOTES DEMOLITION
	DEMOLISH ZONE TO BE DEMOLISHED
	DEMOLISH DASHED RED LINES DENOTES TREE REMOVAL

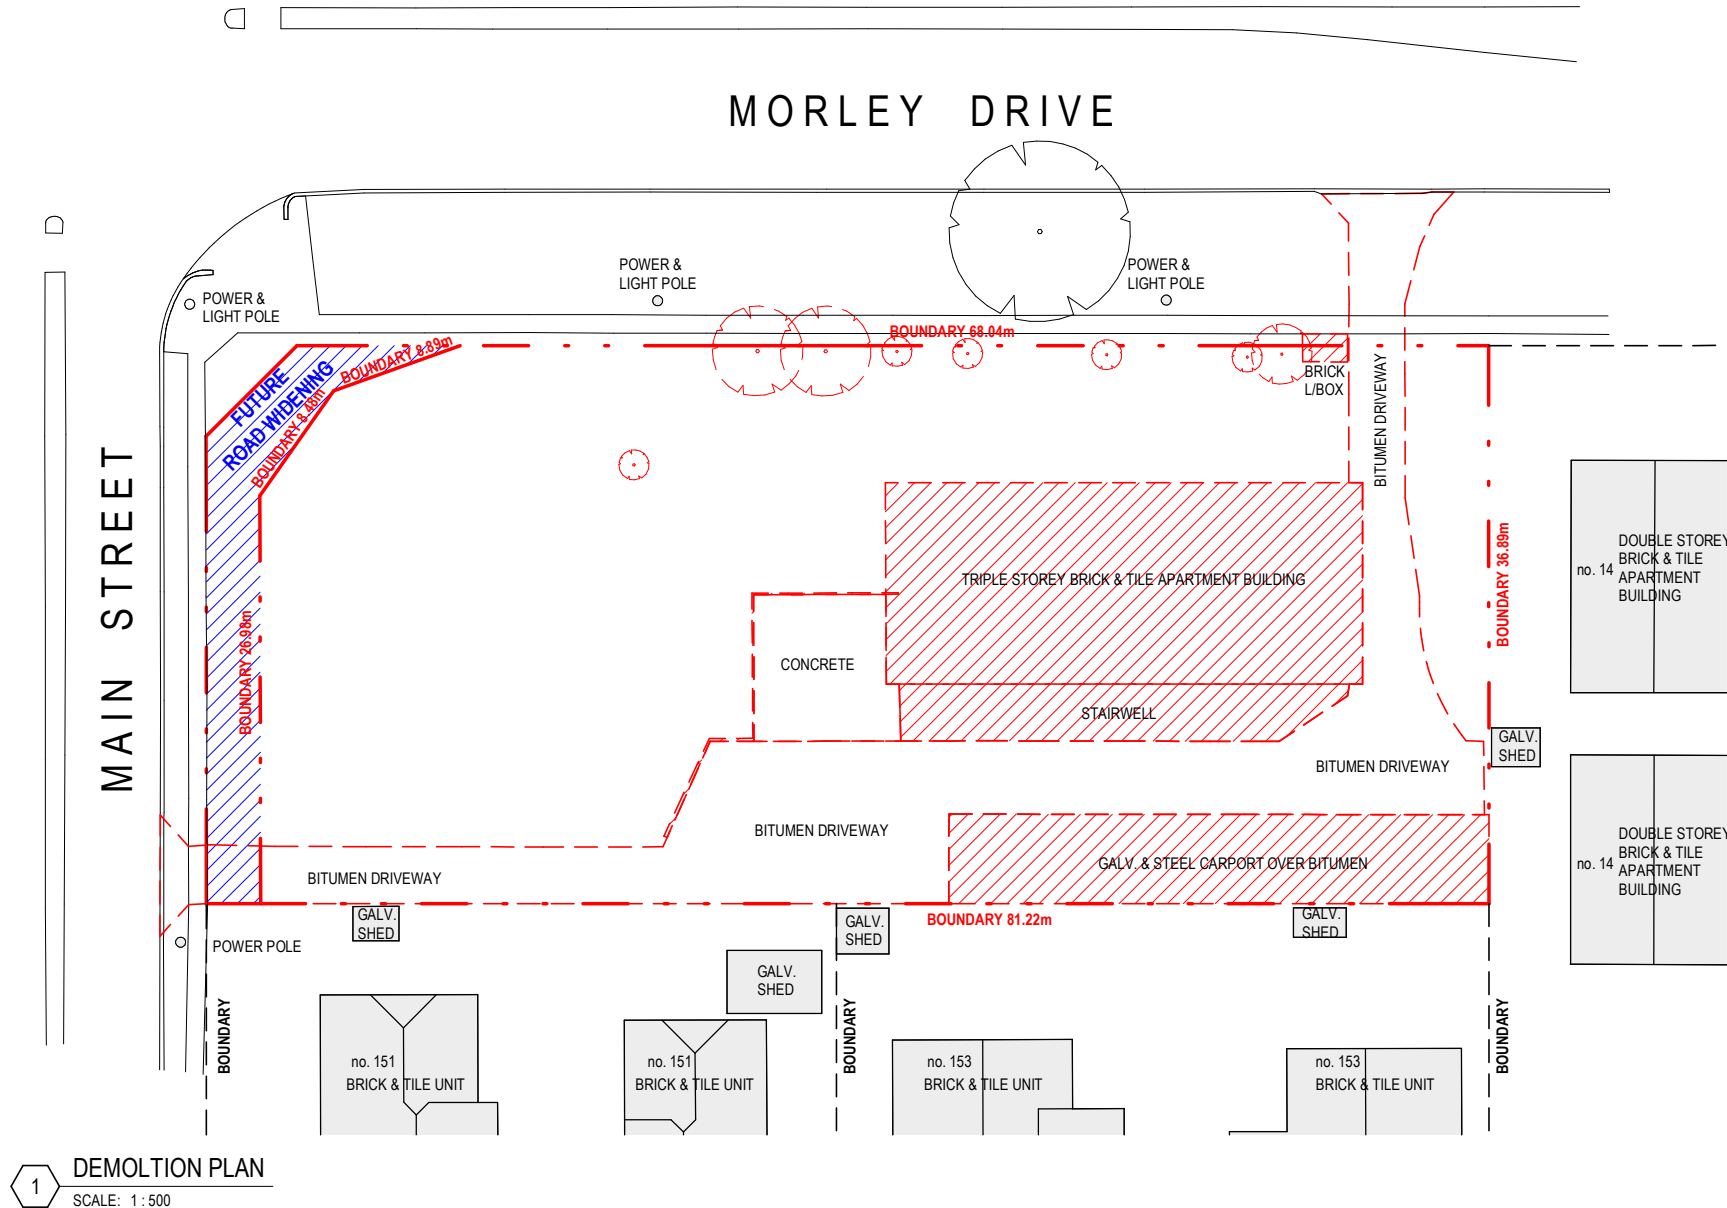


©architectus™

Architectus Australia Pty Ltd is the owner of the copyright subsisting in these drawings, plans, designs and specifications. They must not be used, reproduced or copied, in whole or in part, nor may the information, ideas and concepts therein contained (which are confidential to Architectus Australia Pty Ltd) be disclosed to any person without the prior written consent of that company.

Nominated Architect
Ray Brown, NSWARB 6359

Do not scale drawings. Verify all dimensions on site

issue	amendment	date
A	DA SUBMISSION	25/03/2021

 

DEPARTMENT OF PLANNING, LANDS AND HERITAGE	
DATE	FILE
07-Apr-2021	SDAU-007-20

architectus™

Adelaide
Brisbane
Melbourne
Sydney
Perth

Architectus Perth
QV1 Upper Plaza West
250 St. Georges Terrace
Perth WA 6000
T (61 8) 9412 8355

perth@architectus.com.au
ABN 90 131 245 684

checked AS
drawn FMK
scale 1:250 @ A3

project 10 MORLEY DRIVE, TUART HILL

drawing


DEMOLITION PLAN

project no 200611
issue

drawing no. DA0500 A

26/03/2021 11:56:15 AM

MORLEY DRIVE

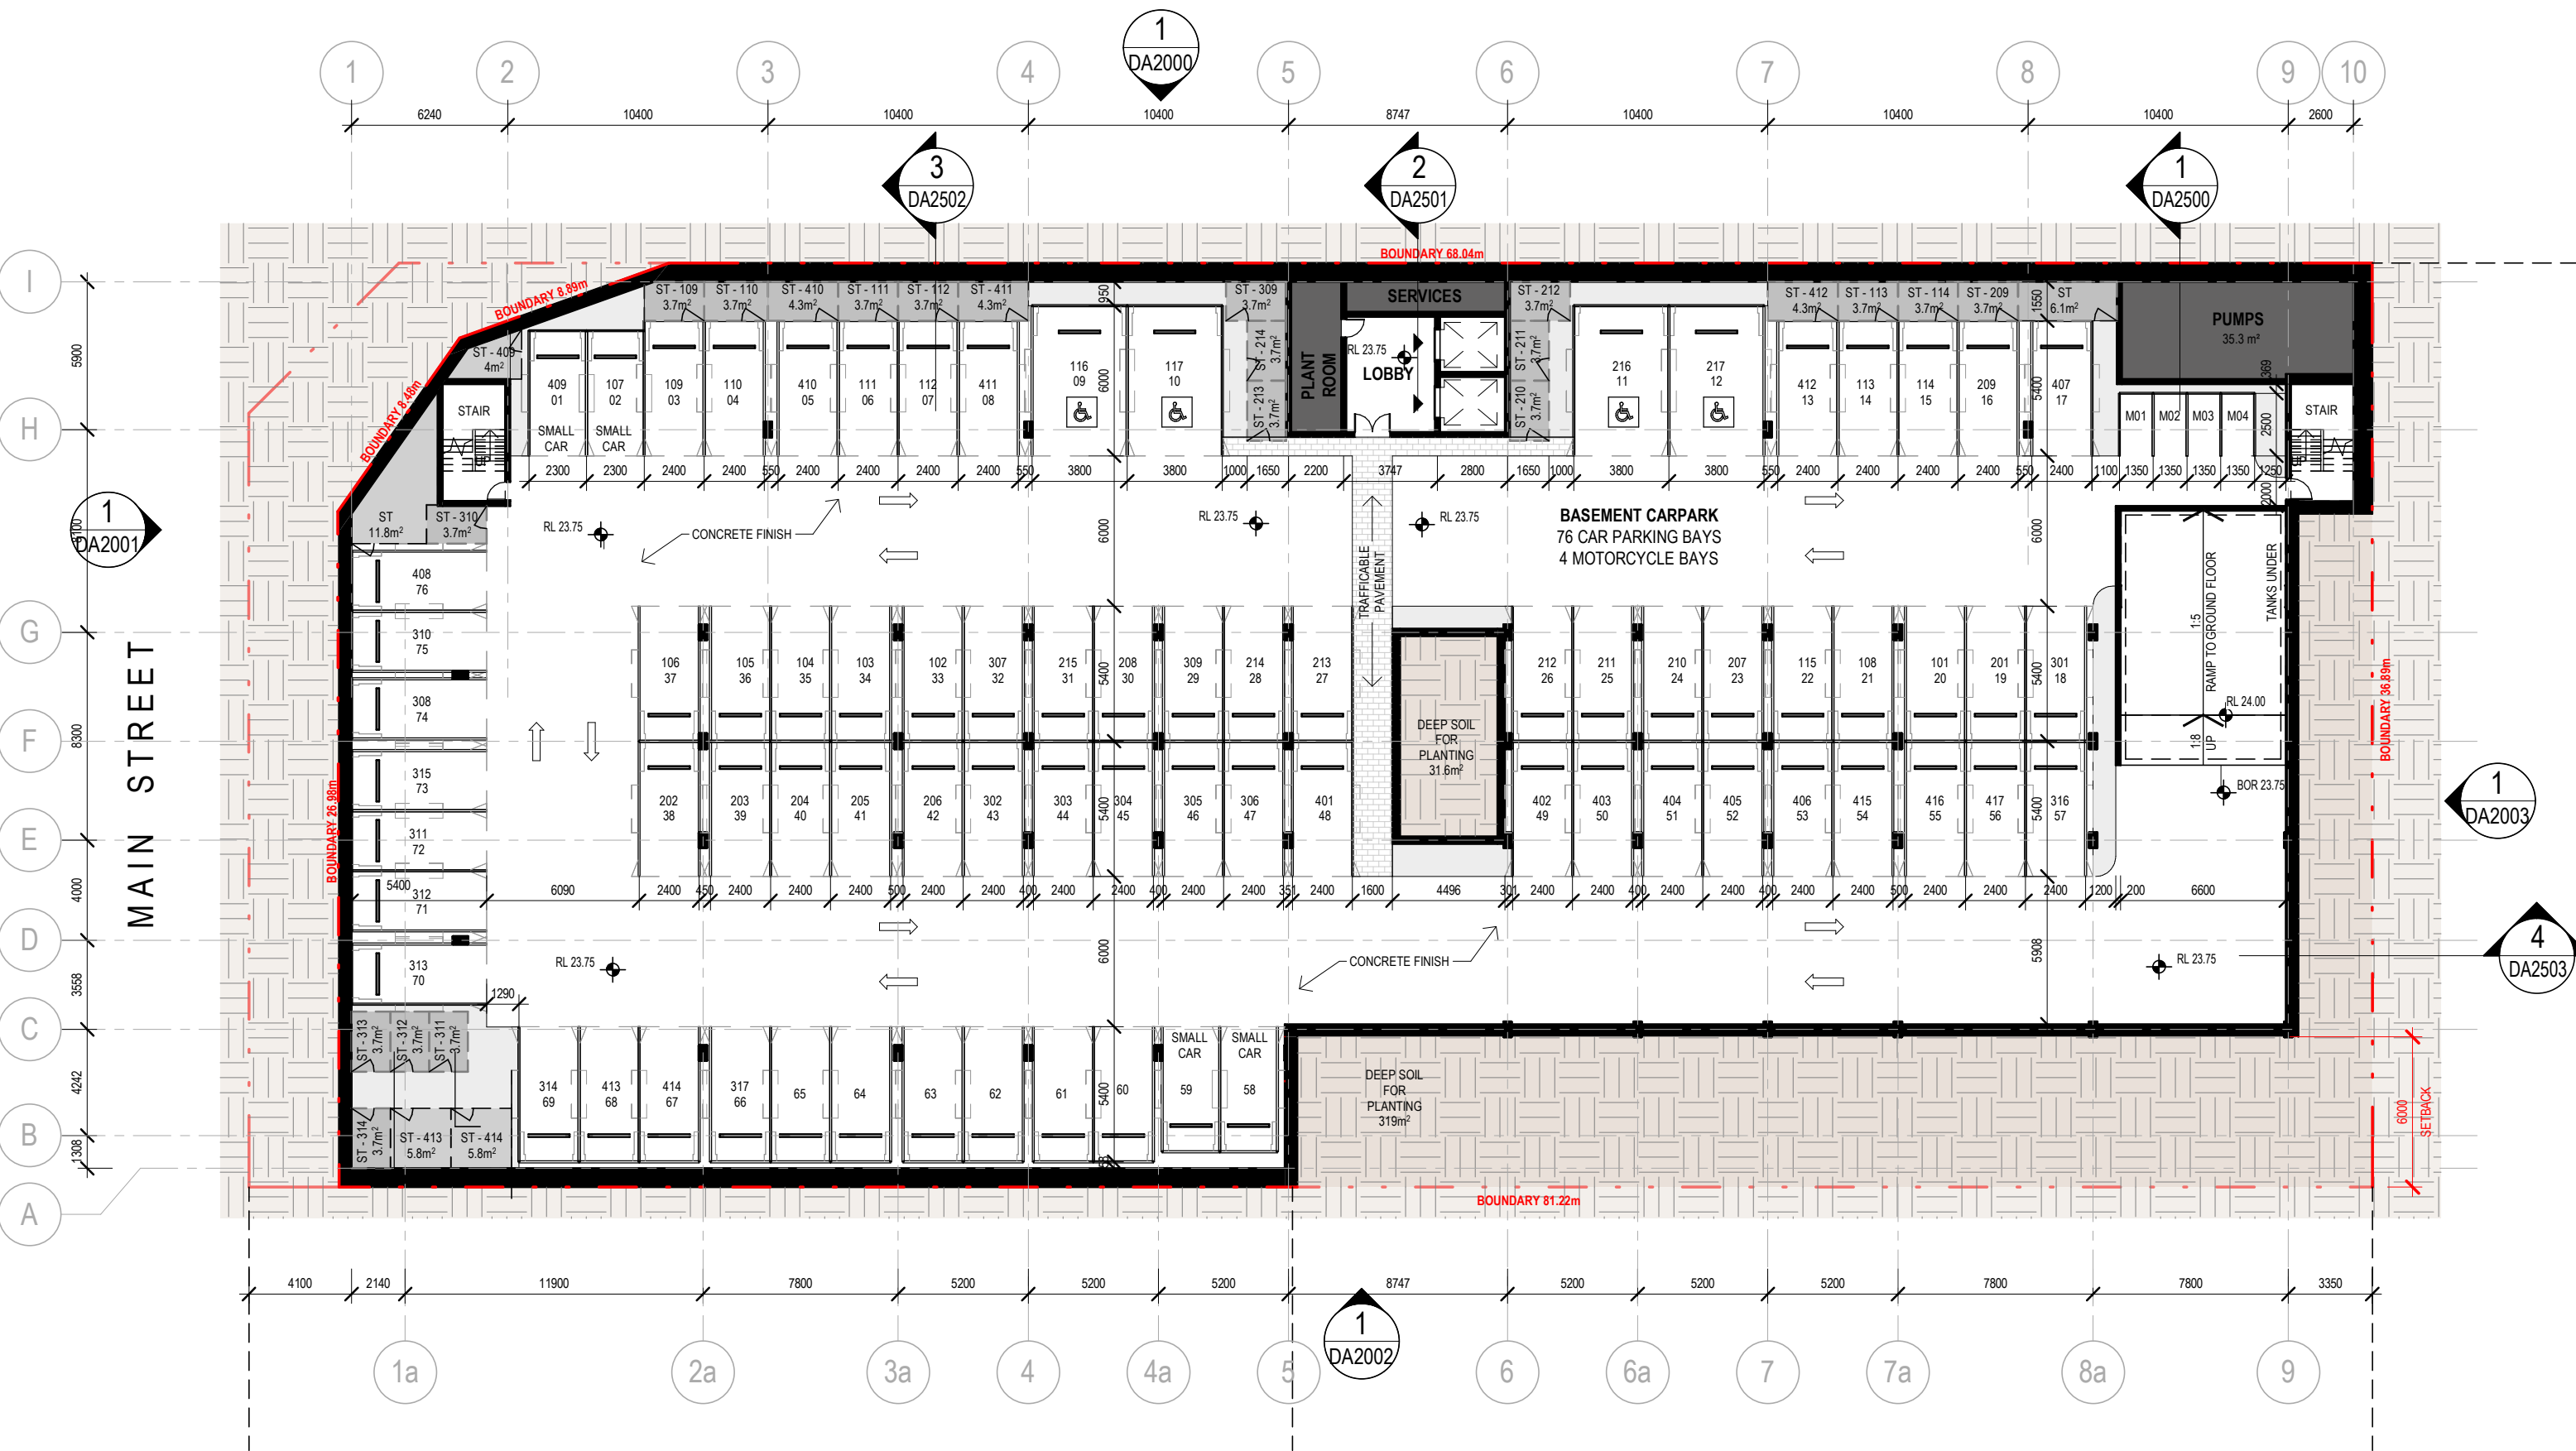


architectus™

Architectus Australia Pty Ltd is the owner of the copyright subsisting in these drawings, plans, designs and specifications. They must not be used, reproduced or copied, in whole or in part, nor may the information, ideas and concepts therein contained (which are confidential to Architectus Australia Pty Ltd) be disclosed to any person without the prior written consent of that company.

Nominated Architect
Ray Brown, NSWARB 6359

Do not scale drawings. Verify all dimensions on site

issue	amendment	date
A	DA SUBMISSION	25/03/2021

 

architectus™

Architectus Perth
QV/1 Upper Plaza West
250 St. Georges Terrace
Perth WA 6000
T (61 8) 9412 8355

perth@architectus.com.au
ABN 90 131 245 684

checked AS
drawn FMK
scale 1:250 @ A3

project 10 MORLEY DRIVE, TUART HILL


drawing BASEMENT PLAN

project no 200611
issue A

drawing no. DA1000

26/03/2021 11:56:19 AM

SITE LEGEND	
	BOUNDARY LINE
	SITE BUILDING
	CONTEXT BUILDING
	FUTURE ROAD WIDENING

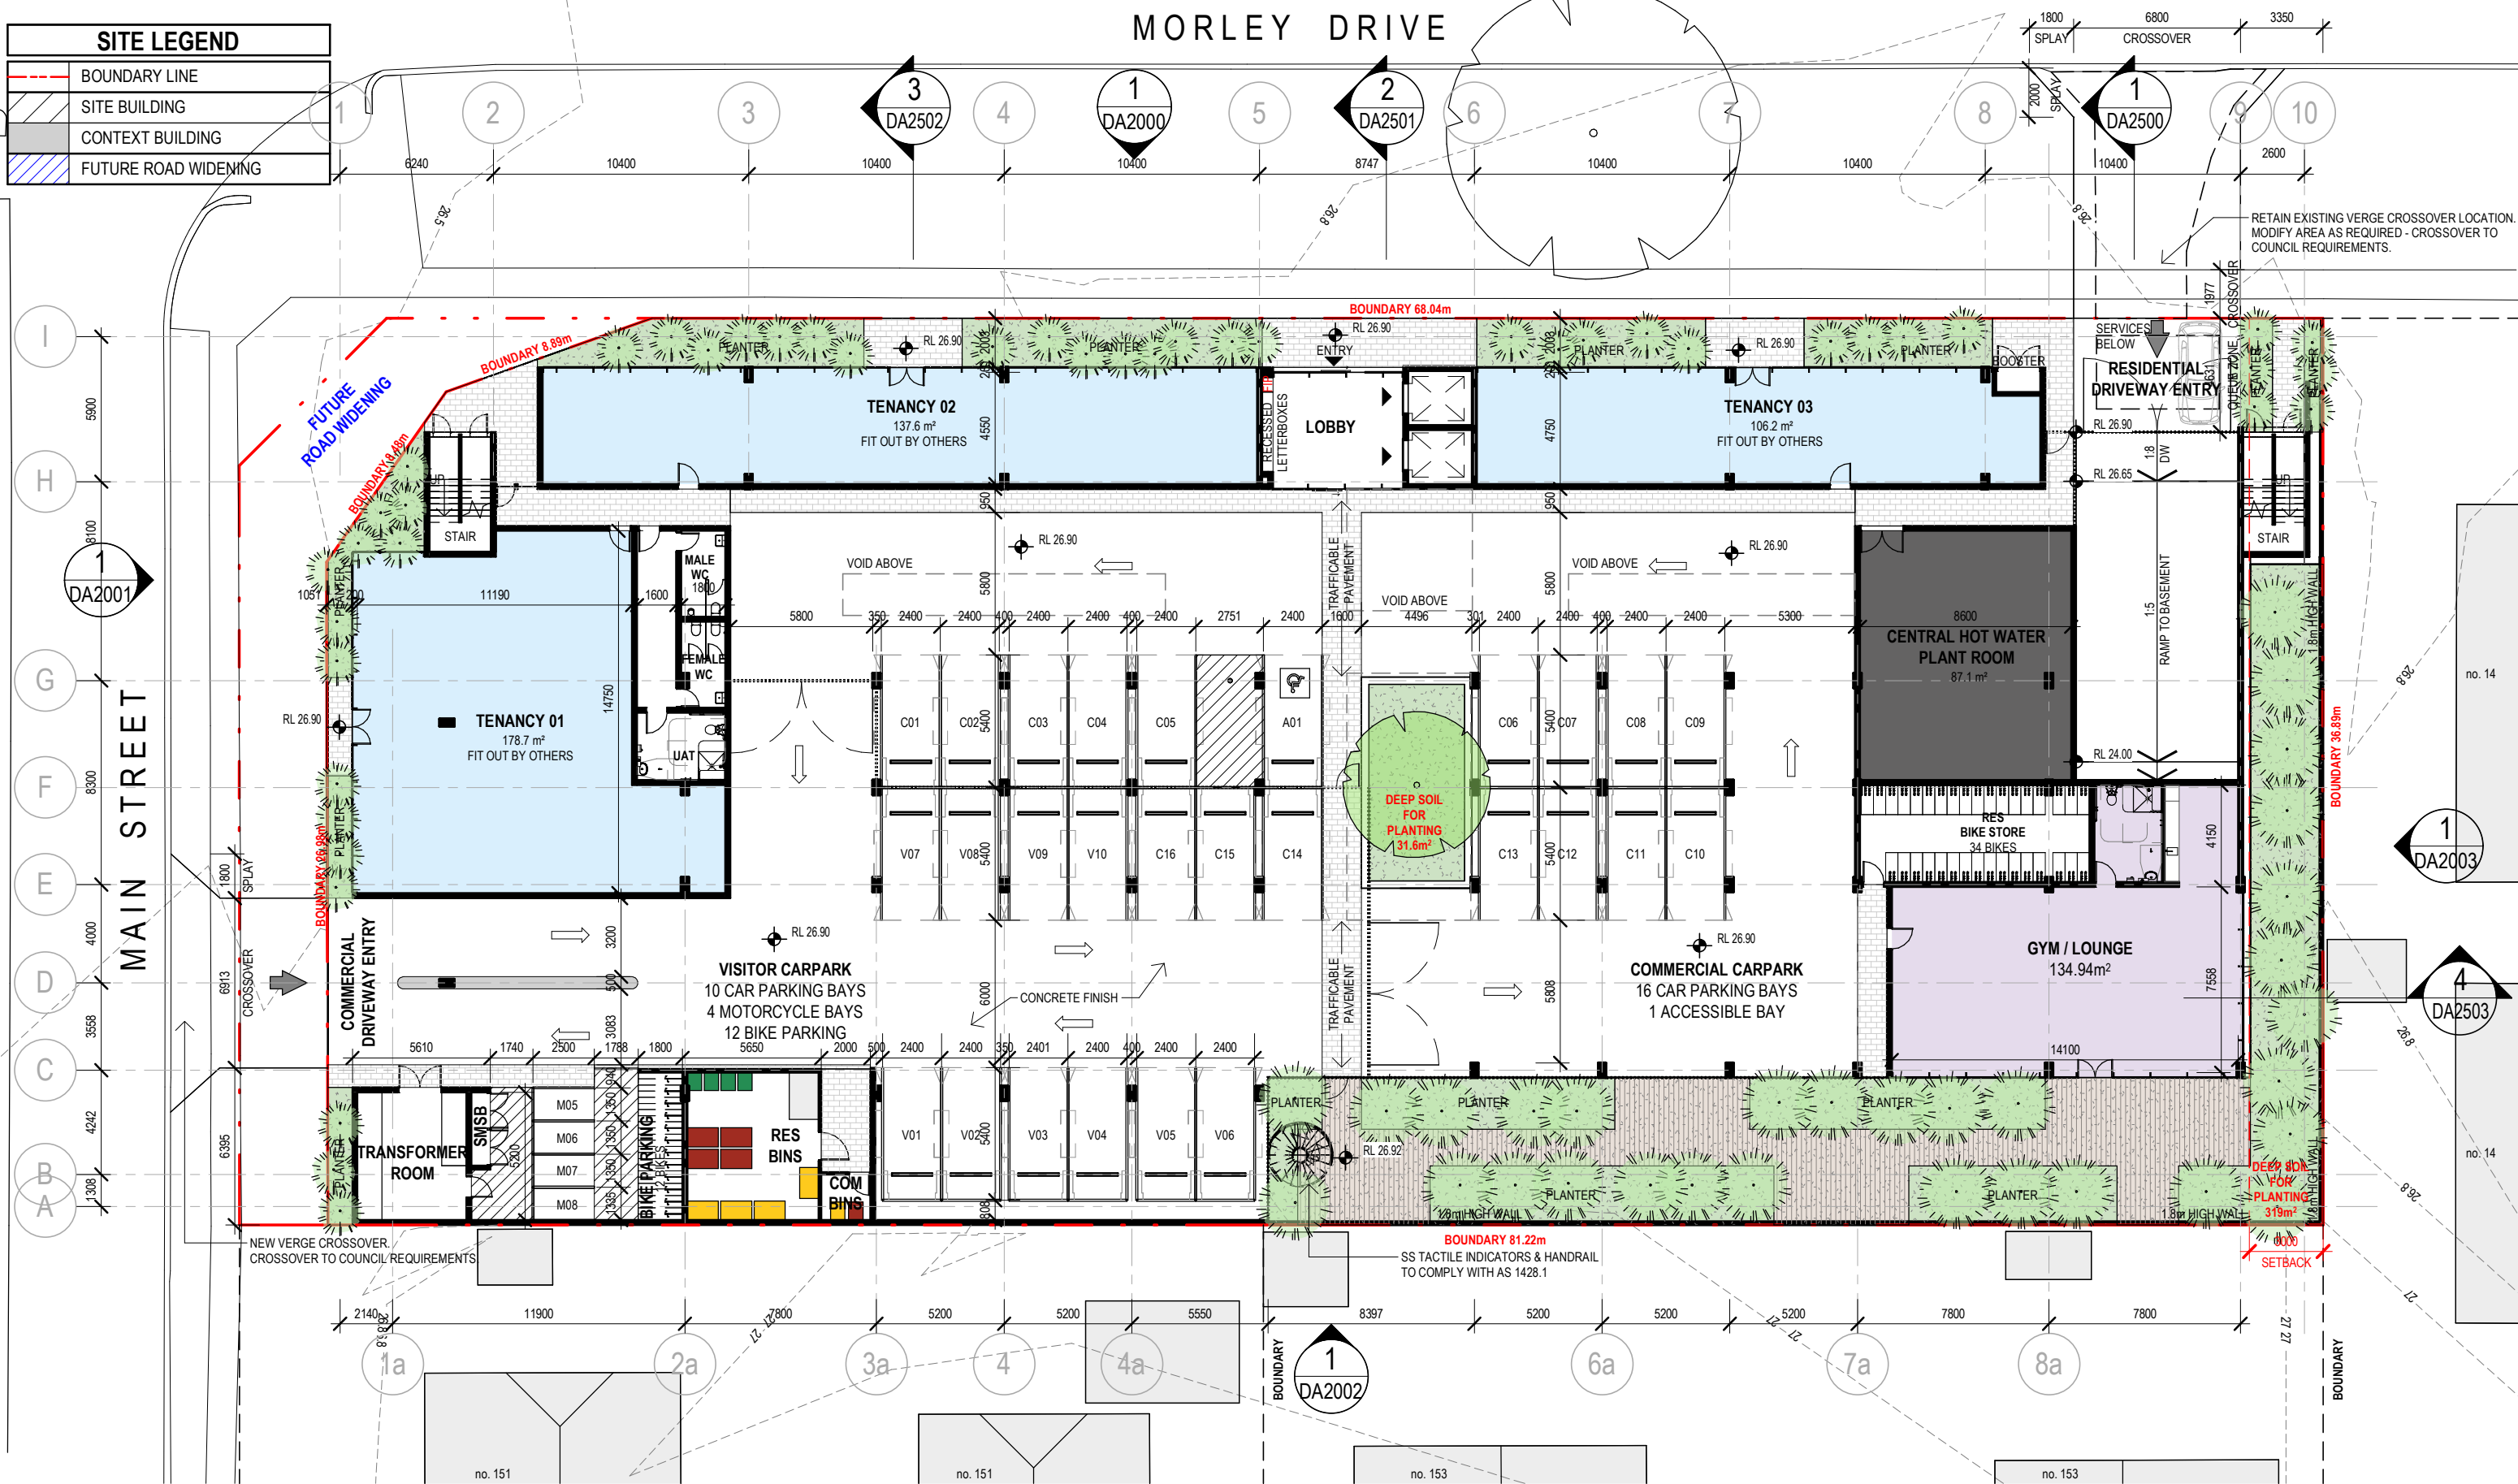


©architectus™

Architectus Australia Pty Ltd is the owner of the copyright subsisting in these drawings, plans, designs and specifications. They must not be used, reproduced or copied, in whole or in part, nor may the information, ideas and concepts therein contained (which are confidential to Architectus Australia Pty Ltd) be disclosed to any person without the prior written consent of that company.

Nominated Architect
Ray Brown, NSWARB 6359

Do not scale drawings. Verify all dimensions on site

issue	amendment	date
A	DA SUBMISSION	25/03/2021

 

DEPARTMENT OF PLANNING, LANDS AND HERITAGE	
DATE	FILE
07-Apr-2021	SDAU-007-20

architectus™

Architectus Perth
QV1 Upper Plaza West
250 St. Georges Terrace
Perth WA 6000
T (61 8) 9412 8355

perth@architectus.com.au
ABN 90 131 245 684

checked AS
drawn FMK
scale 1:250 @ A3

project 10 MORLEY DRIVE, TUART HILL

drawing

GROUND FLOOR PLAN

project no 200611

issue

drawing no. DA1001 A

26/03/2021 11:56:27 AM

MORLEY DRIVE

UNIT TYPE KEY	
1A : 1 BEDROOM	
2A : 2 BEDROOM	
2B - 2 BEDROOM	
2C - 2 BEDROOM	
2D - 2 BEDROOM	
2E - 2 BEDROOM	
2F - 2 BEDROOM	
3A - 2 BEDROOM	
3B - 3 BEDROOM	




©architectus™

Architectus Australia Pty Ltd is the owner of the copyright subsisting in these drawings, plans, designs and specifications. They must not be used, reproduced or copied, in whole or in part, nor may the information, ideas and concepts therein contained (which are confidential to Architectus Australia Pty Ltd) be disclosed to any person without the prior written consent of that company.

Nominated Architect
Ray Brown, NSWARB 6359

Do not scale drawings. Verify all dimensions on site

issue	amendment	date
A	DA SUBMISSION	25/03/2021

 

DEPARTMENT OF PLANNING, LANDS AND HERITAGE	
DATE	FILE
07-Apr-2021	SDAU-007-20

architectus™

Architectus Perth
QV1 Upper Plaza West
250 St. Georges Terrace
Perth WA 6000
T (61 8) 9412 8355

checked AS
drawn KB
scale 1:250 @ A3

project 10 MORLEY DRIVE, TUART HILL

drawing LEVEL 01 PLAN


project no 200611

drawing no. DA1002 issue A

26/03/2021 11:56:39 AM

MORLEY DRIVE

UNIT TYPE KEY	
1A : 1 BEDROOM	
2A : 2 BEDROOM	
2B - 2 BEDROOM	
2C - 2 BEDROOM	
2D - 2 BEDROOM	
2E - 2 BEDROOM	
2F - 2 BEDROOM	
3A - 2 BEDROOM	
3B - 3 BEDROOM	

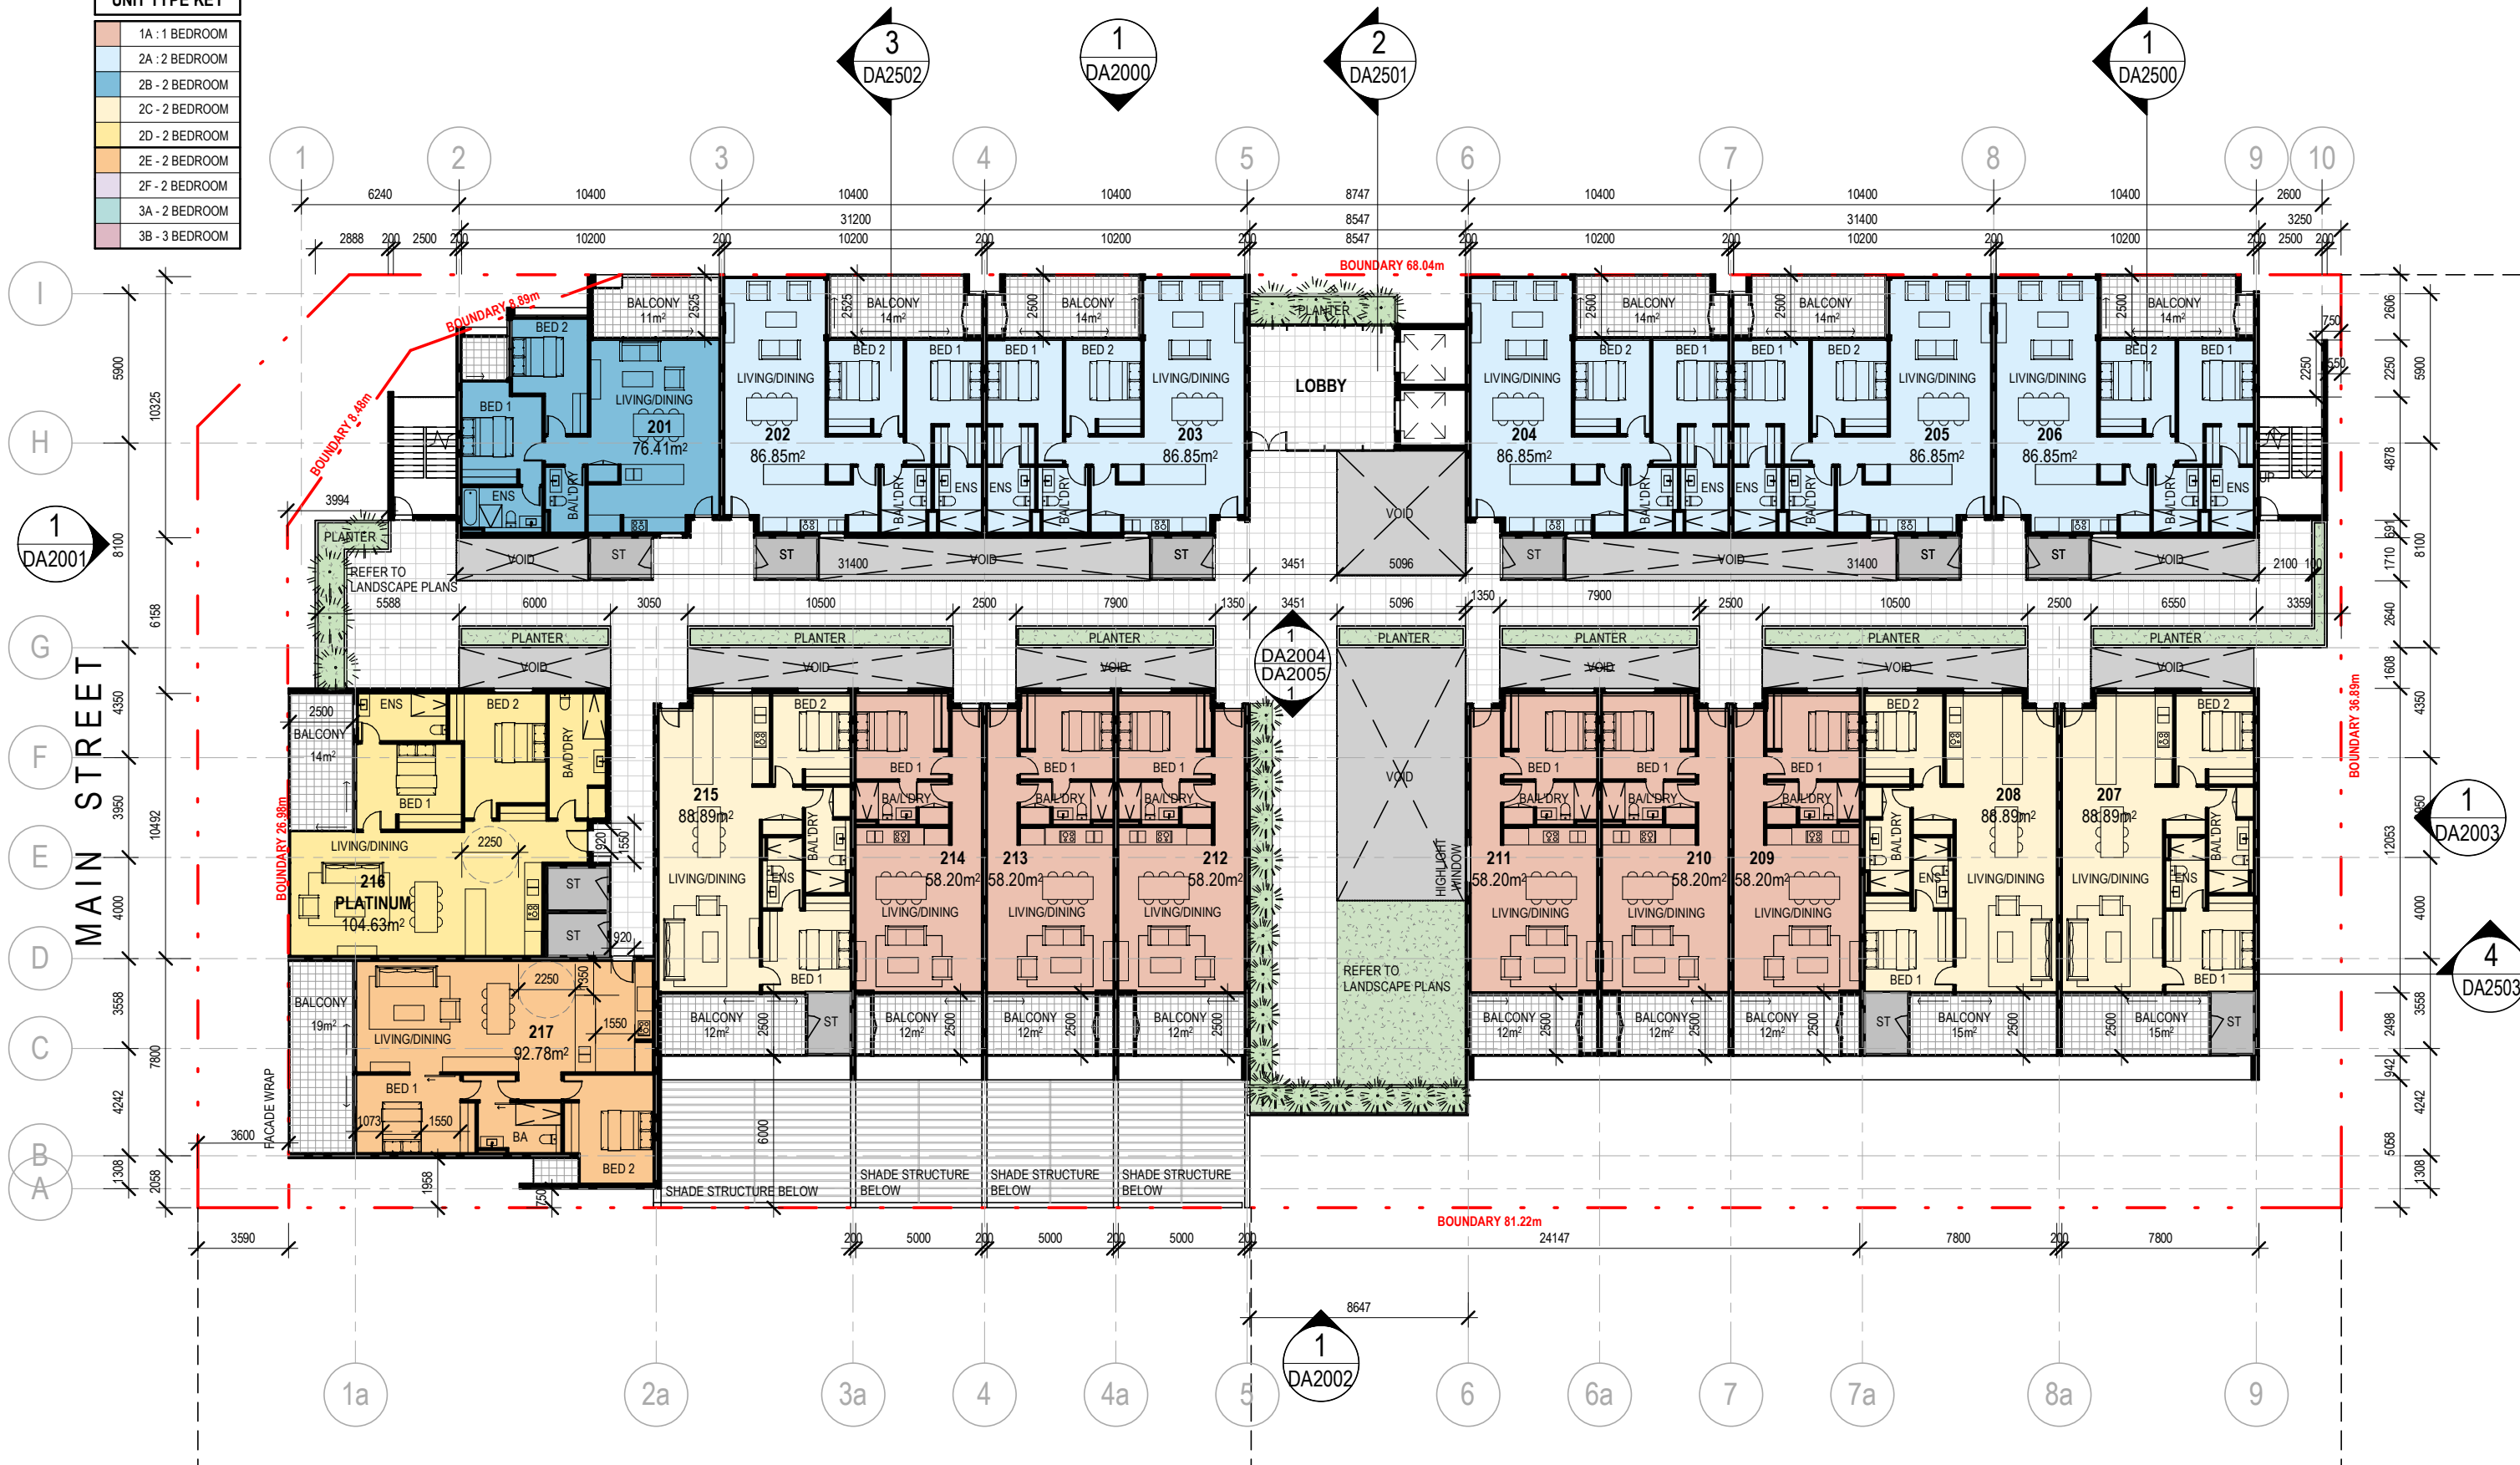


©architectus™

Architectus Australia Pty Ltd is the owner of the copyright subsisting in these drawings, plans, designs and specifications. They must not be used, reproduced or copied, in whole or in part, nor may the information, ideas and concepts therein contained (which are confidential to Architectus Australia Pty Ltd) be disclosed to any person without the prior written consent of that company.

Nominated Architect
Ray Brown, NSWARB 6359

Do not scale drawings. Verify all dimensions on site

issue	amendment	date
A	DA SUBMISSION	25/03/2021

 

DEPARTMENT OF PLANNING, LANDS AND HERITAGE	
DATE	FILE
07-Apr-2021	SDAU-007-20

architectus™

Architectus Perth
QV1 Upper Plaza West
250 St. Georges Terrace
Perth WA 6000
T (61 8) 9412 8355

perth@architectus.com.au
ABN 90 131 245 684

checked AS
drawn KB
scale 1:250 @ A3

project 10 MORLEY DRIVE, TUART HILL

drawing

LEVEL 02 PLAN

project no 200611

drawing no. DA1003 issue A

26/03/2021 11:56:51 AM

MORLEY DRIVE

UNIT TYPE KEY	
1A : 1 BEDROOM	
2A : 2 BEDROOM	
2B - 2 BEDROOM	
2C - 2 BEDROOM	
2D - 2 BEDROOM	
2E - 2 BEDROOM	
2F - 2 BEDROOM	
3A - 2 BEDROOM	
3B - 3 BEDROOM	




architectus™

Architectus Australia Pty Ltd is the owner of the copyright subsisting in these drawings, plans, designs and specifications. They must not be used, reproduced or copied, in whole or in part, nor may the information, ideas and concepts therein contained (which are confidential to Architectus Australia Pty Ltd) be disclosed to any person without the prior written consent of that company.

Nominated Architect
Ray Brown, NSWARB 6359

Do not scale drawings. Verify all dimensions on site

issue	amendment	date
A	DA SUBMISSION	25/03/2021

 

DEPARTMENT OF PLANNING, LANDS AND HERITAGE	
DATE	FILE
07-Apr-2021	SDAU-007-20

architectus™

Adelaide
Brisbane
Melbourne
Sydney
Perth

Architectus Perth
QV1 Upper Plaza West
250 St. Georges Terrace
Perth WA 6000
T (61 8) 9412 8355

perth@architectus.com.au
ABN 90 131 245 684

checked AS
drawn KB
scale 1:250 @ A3

project 10 MORLEY DRIVE, TUART HILL

drawing

LEVEL 03 PLAN

project no 200611

issue

drawing no. DA1004 A

26/03/2021 11:57:02 AM




©architectus™

Architectus Australia Pty Ltd is the owner of the copyright subsisting in these drawings, plans, designs and specifications. They must not be used, reproduced or copied, in whole or in part, nor may the information, ideas and concepts therein contained (which are confidential to Architectus Australia Pty Ltd) be disclosed to any person without the prior written consent of that company.

Nominated Architect
Ray Brown, NSWARB 6359

Do not scale drawings. Verify all dimensions on site

issue	amendment	date
A	DA SUBMISSION	25/03/2021

 

DEPARTMENT OF PLANNING, LANDS AND HERITAGE	
DATE	FILE
07-Apr-2021	SDAU-007-20

architectus™

Adelaide
Brisbane
Melbourne
Sydney
Perth

Architectus Perth
QV1 Upper Plaza West
250 St. Georges Terrace
Perth WA 6000
T (61 8) 9412 8355

perth@architectus.com.au
ABN 90 131 245 684

checked AS
drawn KB
scale 1:250 @ A3

project 10 MORLEY DRIVE, TUART HILL


drawing LEVEL 04 PLAN

project no 200611

drawing no. DA1005 issue A

26/03/2021 11:57:23 AM

UNIT TYPE KEY	
1A : 1 BEDROOM	
2A : 2 BEDROOM	
2B - 2 BEDROOM	
2C - 2 BEDROOM	
2D - 2 BEDROOM	
2E - 2 BEDROOM	
2F - 2 BEDROOM	
3A - 2 BEDROOM	
3B - 3 BEDROOM	

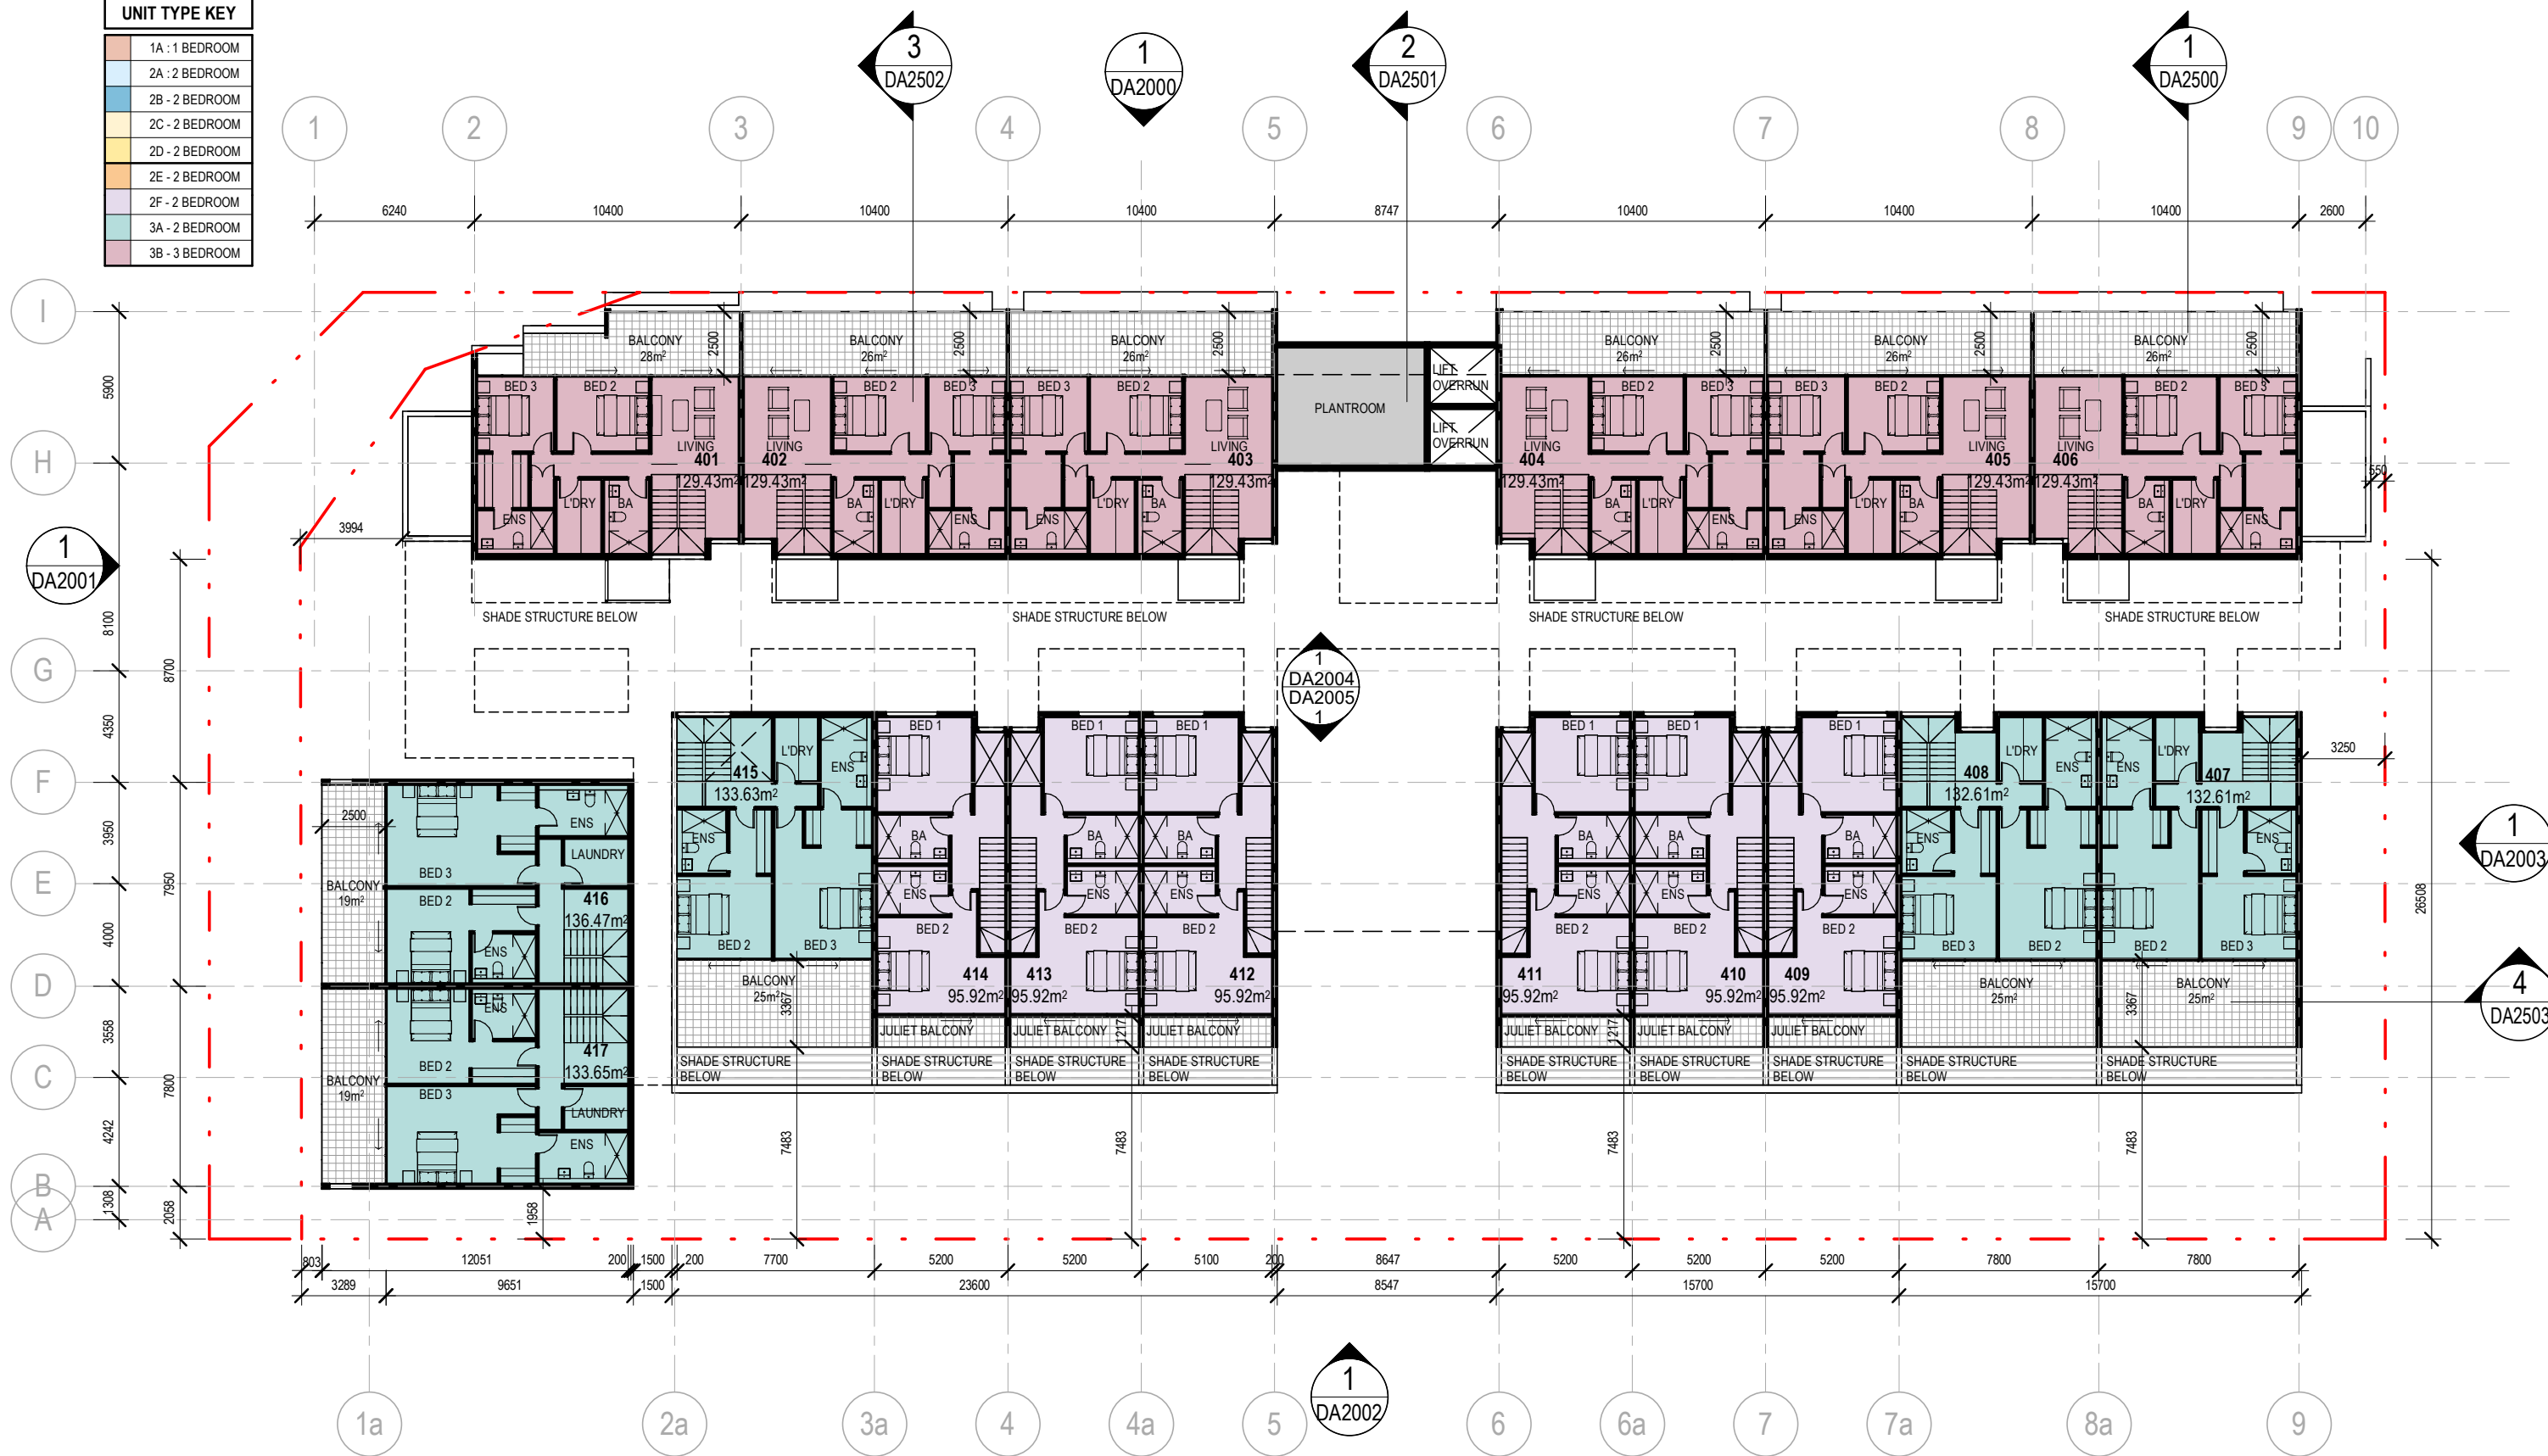


©architectus™

Architectus Australia Pty Ltd is the owner of the copyright subsisting in these drawings, plans, designs and specifications. They must not be used, reproduced or copied, in whole or in part, nor may the information, ideas and concepts therein contained (which are confidential to Architectus Australia Pty Ltd) be disclosed to any person without the prior written consent of that company.

Nominated Architect
Ray Brown, NSWARB 6359

Do not scale drawings. Verify all dimensions on site

issue	amendment	date
A	DA SUBMISSION	25/03/2021

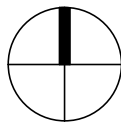

DEPARTMENT OF PLANNING, LANDS AND HERITAGE	
DATE	FILE
07-Apr-2021	SDAU-007-20

architectus™

Adelaide
Brisbane
Melbourne
Sydney
Perth

checked
drawn
scale

Architectus Perth
QV/1 Upper Plaza West
250 St. Georges Terrace
Perth WA 6000
T (61 8) 9412 8355
perth@architectus.com.au
ABN 90 131 245 684

AS
KB
A3
1:250 @

project 10 MORLEY DRIVE, TUART HILL

drawing


LEVEL 05 PLAN

project no 200611

issue

drawing no. DA1006 A

26/03/2021 11:57:32 AM

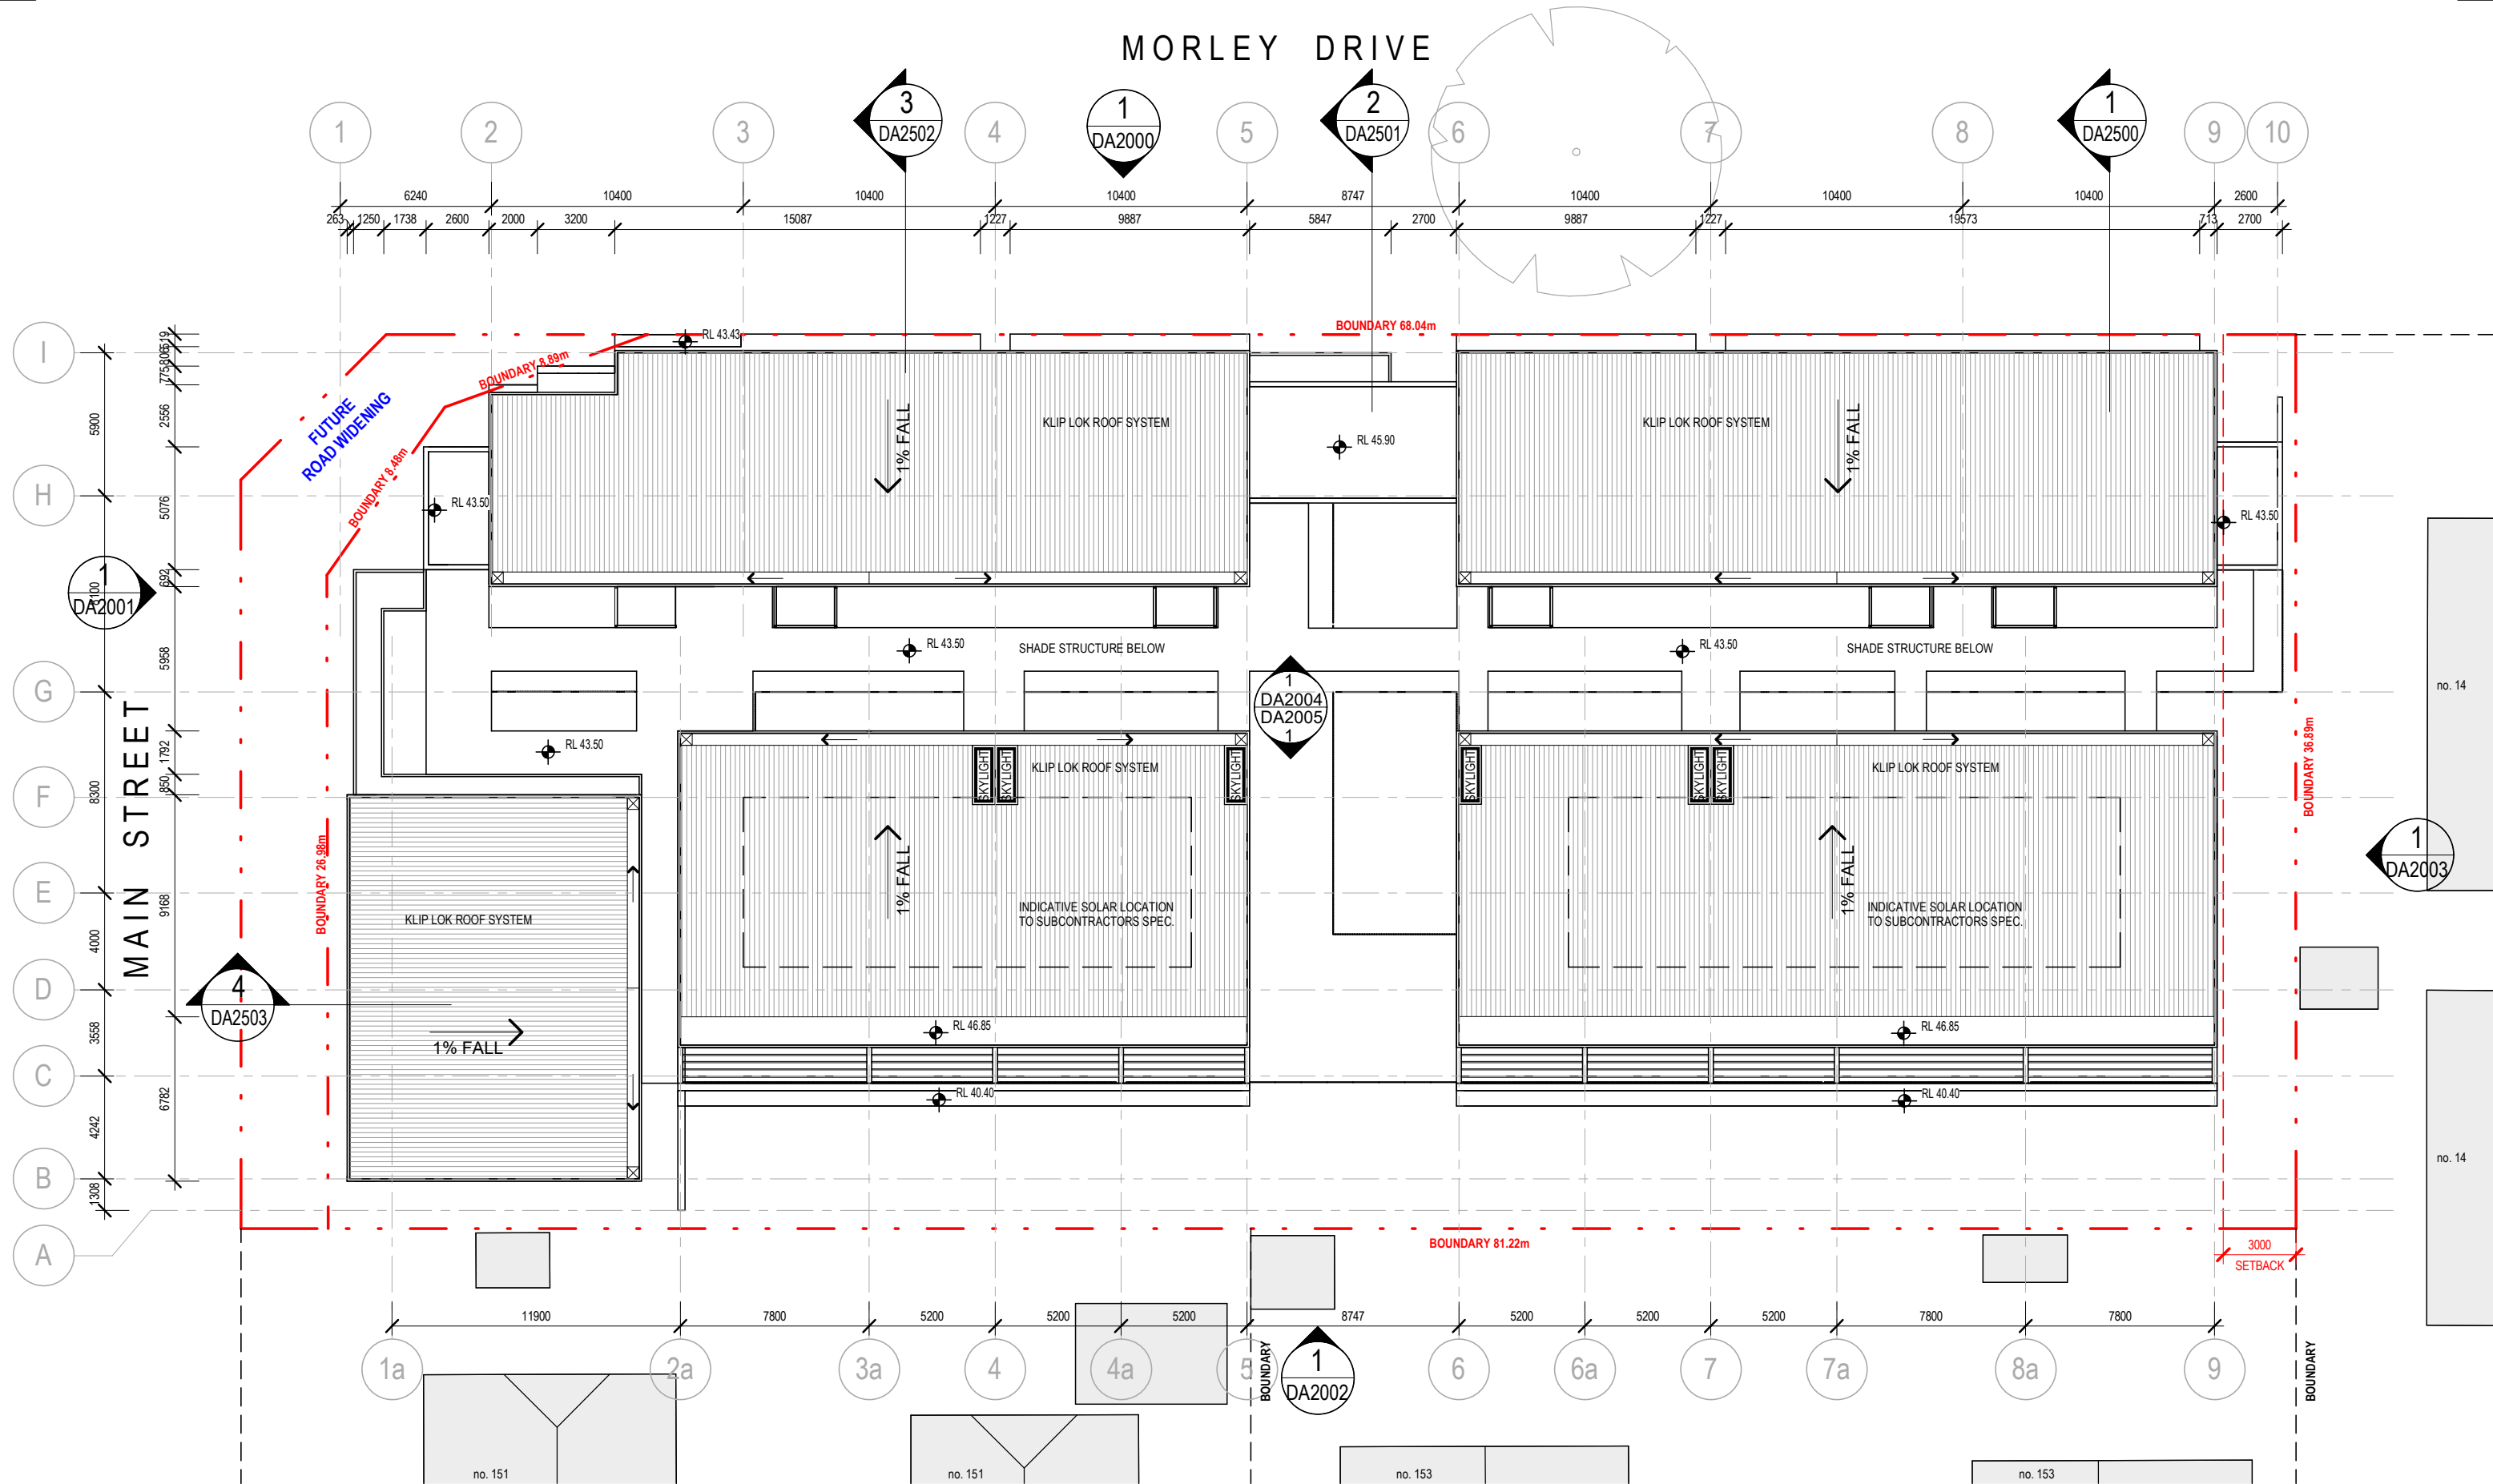


©architectus™

Architectus Australia Pty Ltd is the owner of the copyright subsisting in these drawings, plans, designs and specifications. They must not be used, reproduced or copied, in whole or in part, nor may the information, ideas and concepts therein contained (which are confidential to Architectus Australia Pty Ltd) be disclosed to any person without the prior written consent of that company.

Nominated Architect
Ray Brown, NSWARB 6359

Do not scale drawings. Verify all dimensions on site

issue	amendment	date
A	DA SUBMISSION	25/03/2021

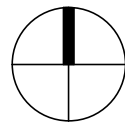

architectus™

Adelaide
Brisbane
Melbourne
Sydney
Perth

checked
drawn
scale

Architectus Perth
QV1 Upper Plaza West
250 St. Georges Terrace
Perth WA 6000
T (61 8) 9412 8355

perth@architectus.com.au
ABN 90 131 245 684

1:250 @ A3

project 10 MORLEY DRIVE, TUART HILL

drawing


ROOF PLAN

project no 200611

issue

drawing no. DA1007 A

26/03/2021 11:57:38 AM

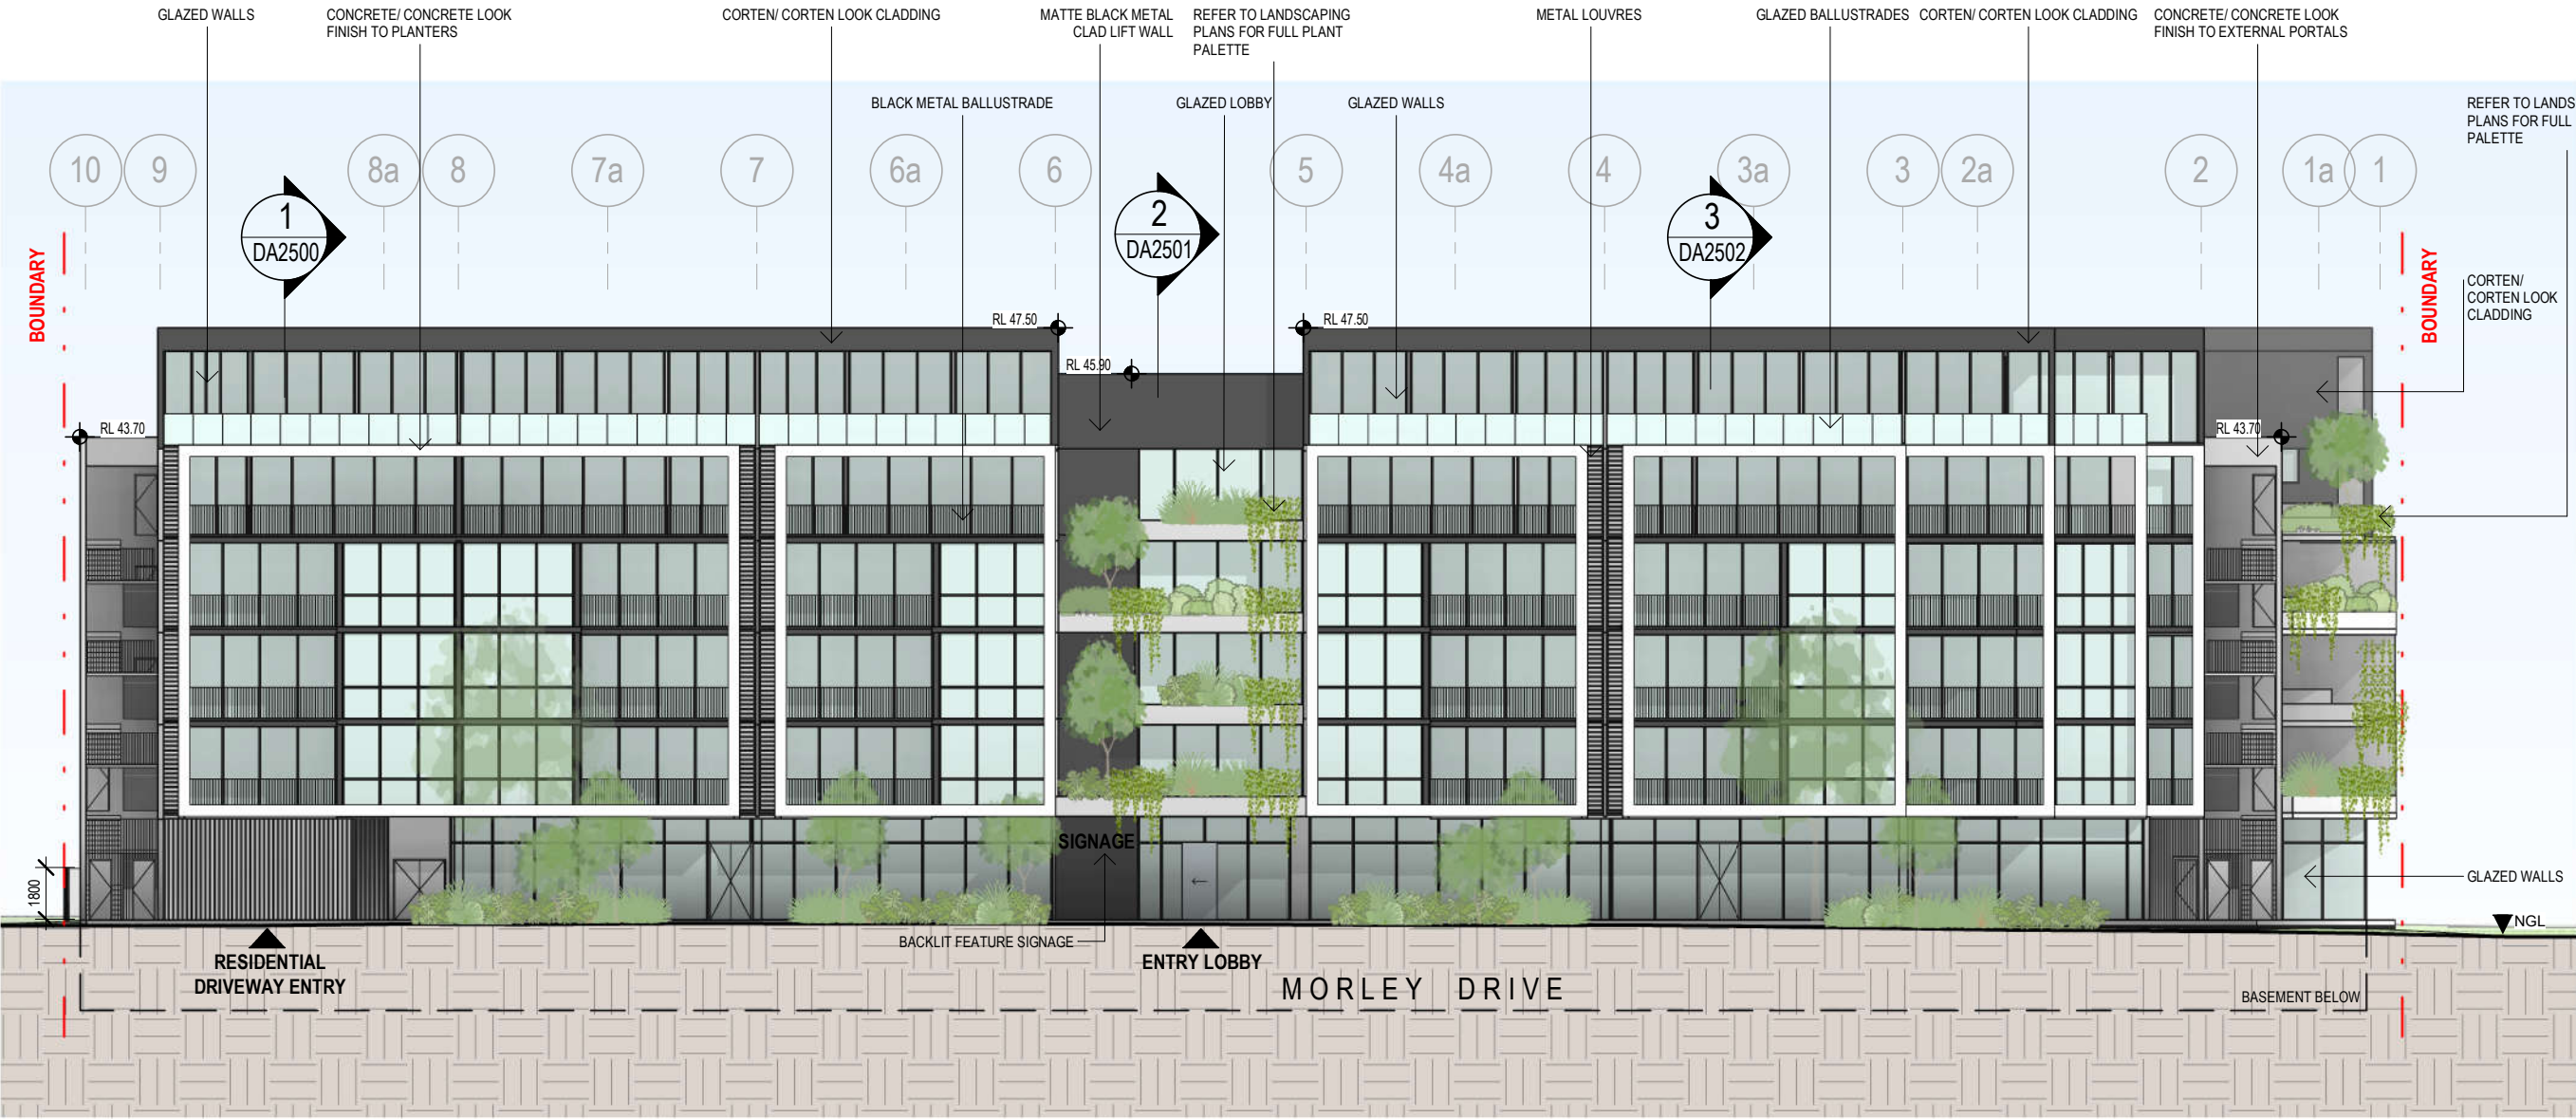

MAIN STREET	ROOF	▽
	RL 46.700	3200
	L05	▽
	RL 43.500	3200
	L04	▽
	RL 40.300	3200
	L03	▽
	RL 37.100	3200
	L02	▽
	RL 33.900	3200
GROUND	L01	▽
	RL 30.700	3800
	▽	
BASEMENT	RL 26.900	3150
	BASEMENT	▽
	RL 23.750	

©architectus™

Architectus Australia Pty Ltd is the owner of the copyright subsisting in these drawings, plans, designs and specifications. They must not be used, reproduced or copied, in whole or in part, nor may the information, ideas and concepts therein contained (which are confidential to Architectus Australia Pty Ltd) be disclosed to any person without the prior written consent of that company.

Nominated Architect
Ray Brown, NSWARB 6359

Do not scale drawings. Verify all dimensions on site

issue	amendment	date
A	DA SUBMISSION	25/03/2021

DEPARTMENT OF PLANNING, LANDS AND HERITAGE	
DATE	FILE
07-Apr-2021	SDAU-007-20

architectus™

Adelaide
Brisbane
Melbourne
Sydney
Perth

Architectus Perth
QV1 Upper Plaza West
250 St. Georges Terrace
Perth WA 6000
T (61 8) 9412 8355

perth@architectus.com.au
ABN 90 131 245 684

checked AS
drawn KB
scale 1:250 @ A3

project 10 MORLEY DRIVE, TUART HILL

drawing


ELEVATION 01

project no 200611

issue

drawing no. DA2000 A

26/03/2021 12:01:22 PM

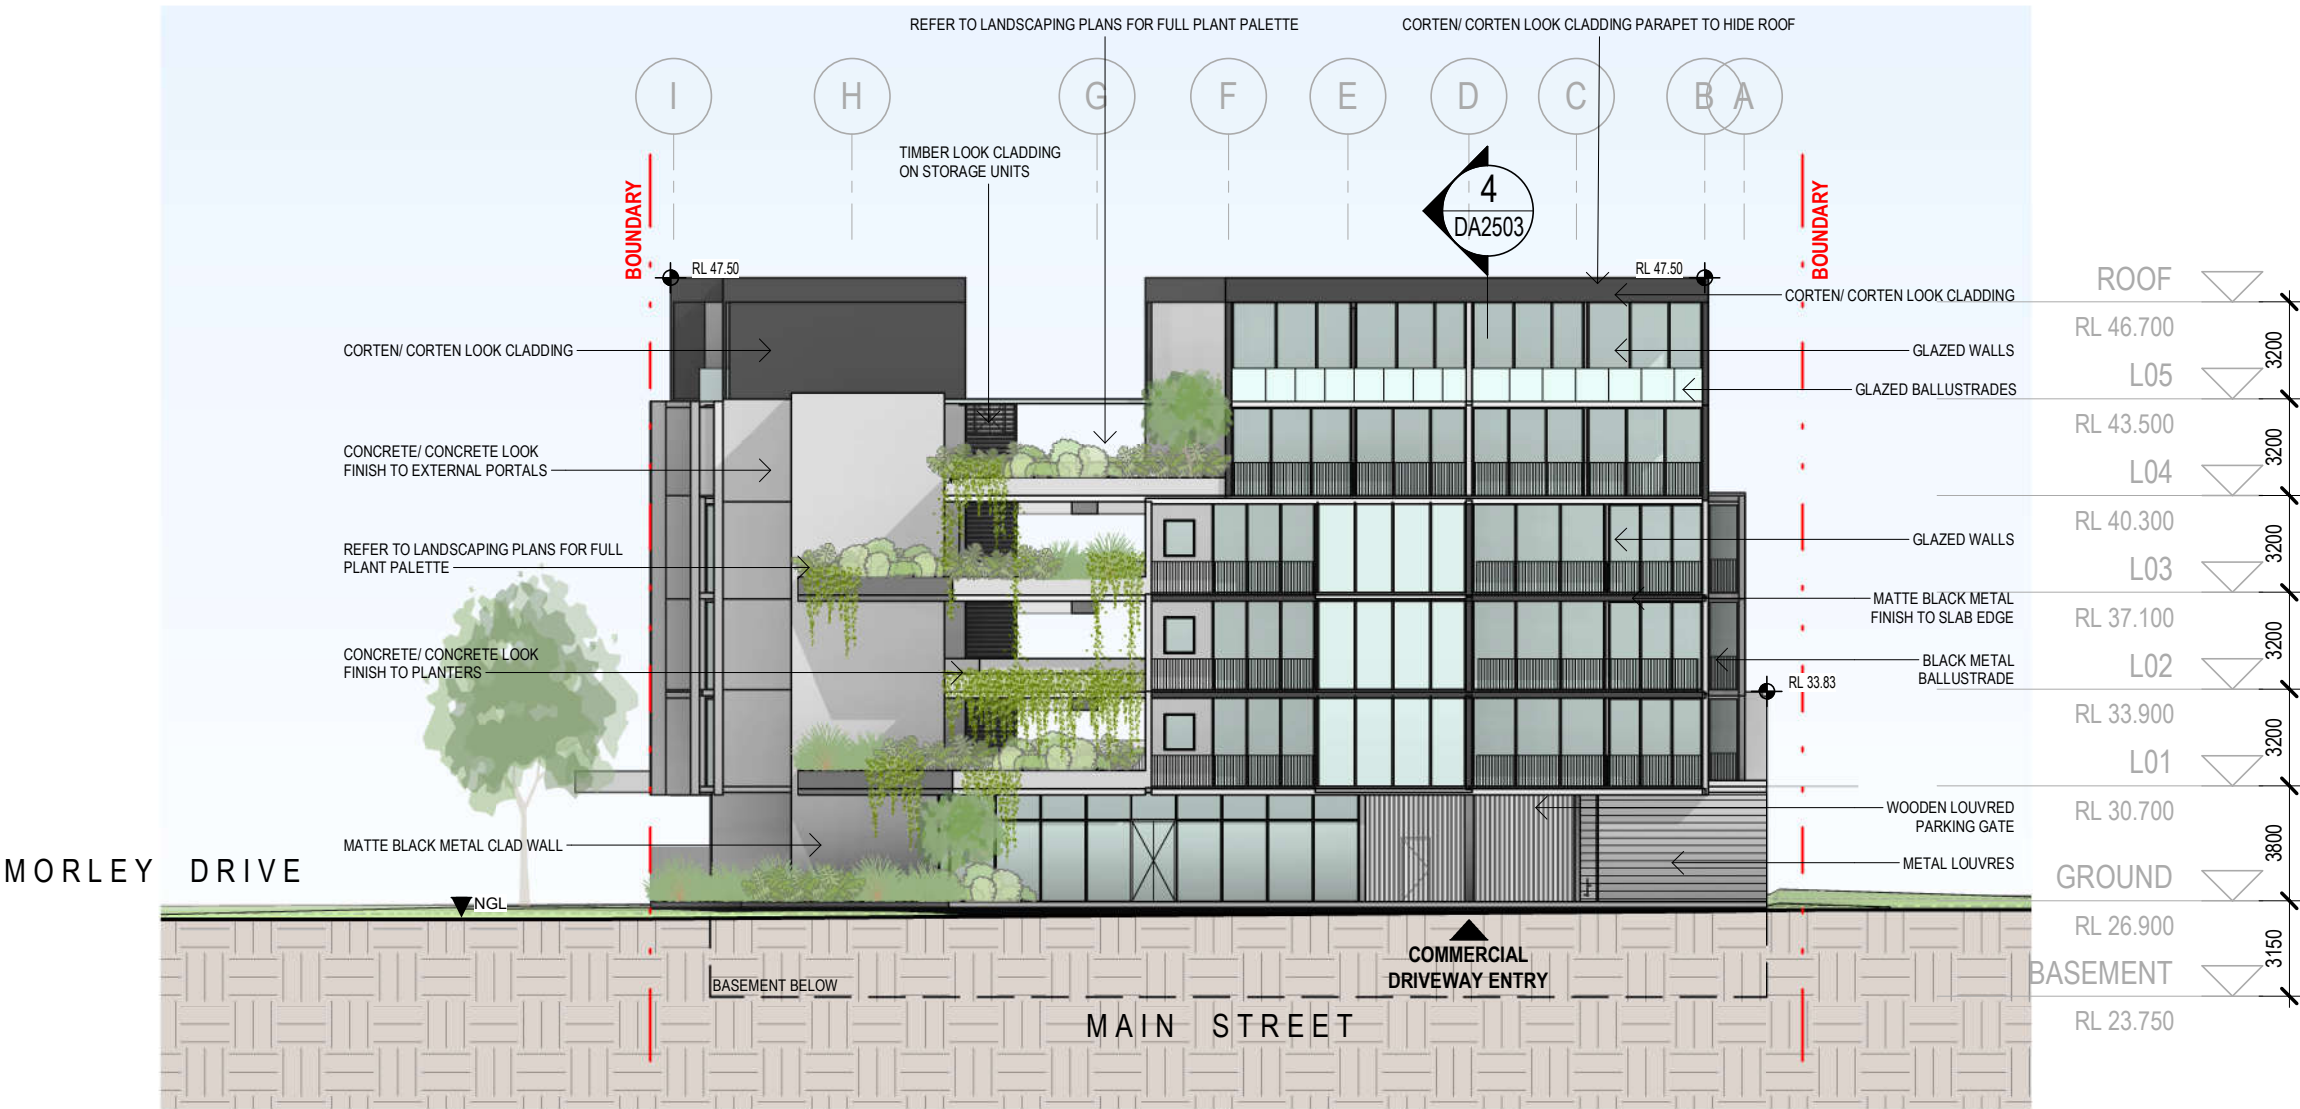

©architectus™

Architectus Australia Pty Ltd is the owner of the copyright subsisting in these drawings, plans, designs and specifications. They must not be used, reproduced or copied, in whole or in part, nor may the information, ideas and concepts therein contained (which are confidential to Architectus Australia Pty Ltd) be disclosed to any person without the prior written consent of that company.

Nominated Architect
Ray Brown, NSWARB 6359

Do not scale drawings. Verify all dimensions on site

issue	amendment	date
A	DA SUBMISSION	25/03/2021

DEPARTMENT OF PLANNING, LANDS AND HERITAGE	
DATE	FILE
07-Apr-2021	SDAU-007-20

architectus™

Architectus Perth
QV1 Upper Plaza West
250 St. Georges Terrace
Perth WA 6000
T (61 8) 9412 8355

perth@architectus.com.au
ABN 90 131 245 684

checked AS
drawn KB
scale 1:250 @ A3


project 10 MORLEY DRIVE, TUART HILL

drawing ELEVATION 02

project no 200611

drawing no. DA2001 issue A

26/03/2021 12:05:03 PM

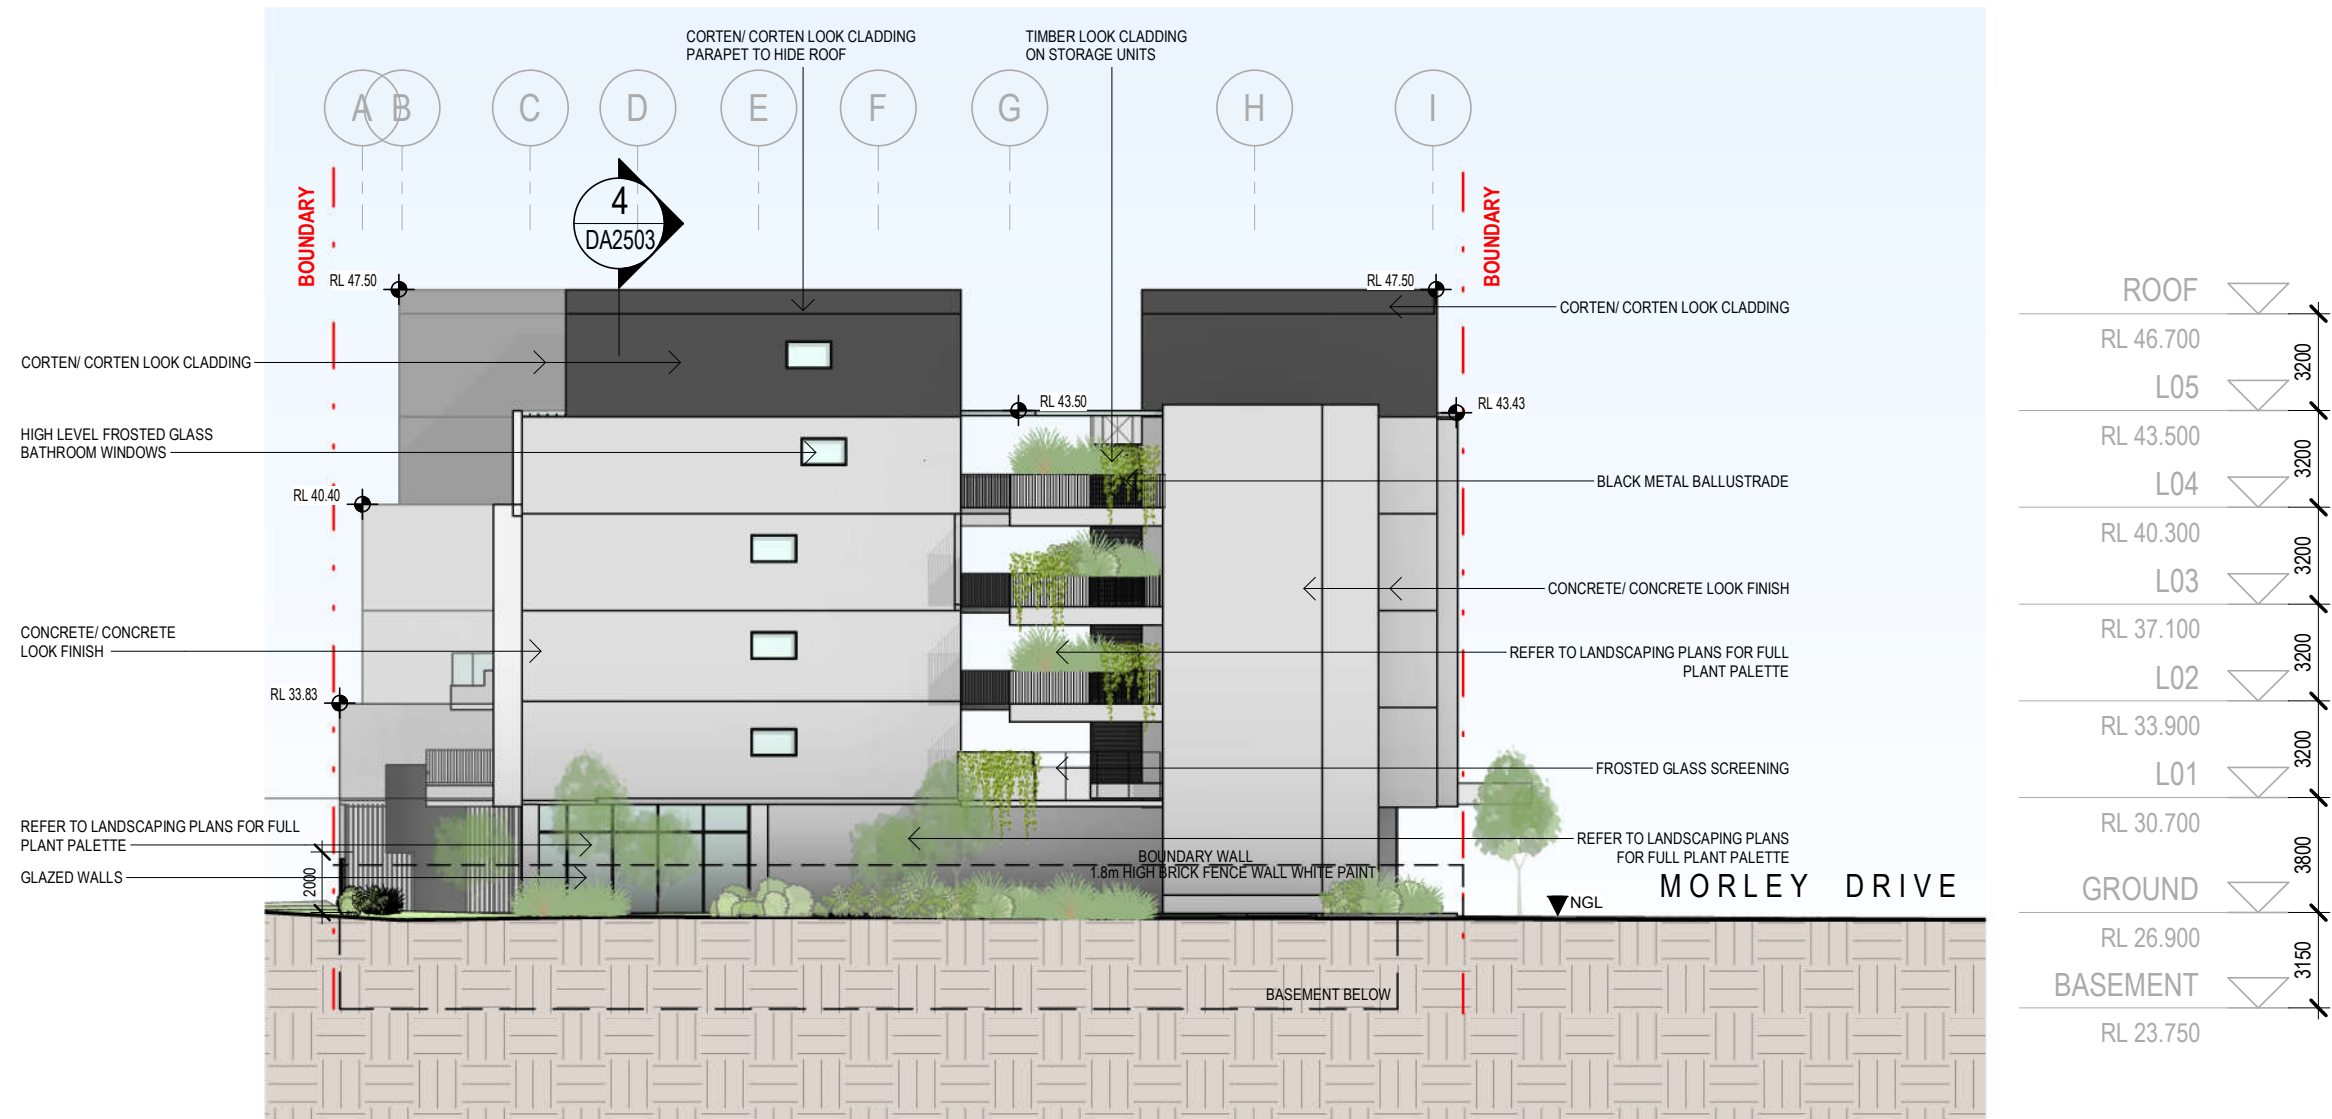

©architectus™

Architectus Australia Pty Ltd is the owner of the copyright subsisting in these drawings, plans, designs and specifications. They must not be used, reproduced or copied, in whole or in part, nor may the information, ideas and concepts therein contained (which are confidential to Architectus Australia Pty Ltd) be disclosed to any person without the prior written consent of that company.

Nominated Architect
Ray Brown, NSWARB 6359

Do not scale drawings. Verify all dimensions on site

issue	amendment	date



architectus™

Adelaide
Brisbane
Melbourne
Sydney
Perth

Architectus Perth
QV1 Upper Plaza West
250 St. Georges Terrace
Perth WA 6000
T (61 8) 9412 8355

perth@architectus.com.au
ABN 90 131 245 684

checked AS
drawn KB
scale 1:250 @ A3


project 10 MORLEY DRIVE, TUART HILL

drawing ELEVATION 04

project no 200611

drawing no. DA2003

26/03/2021 12:12:18 PM

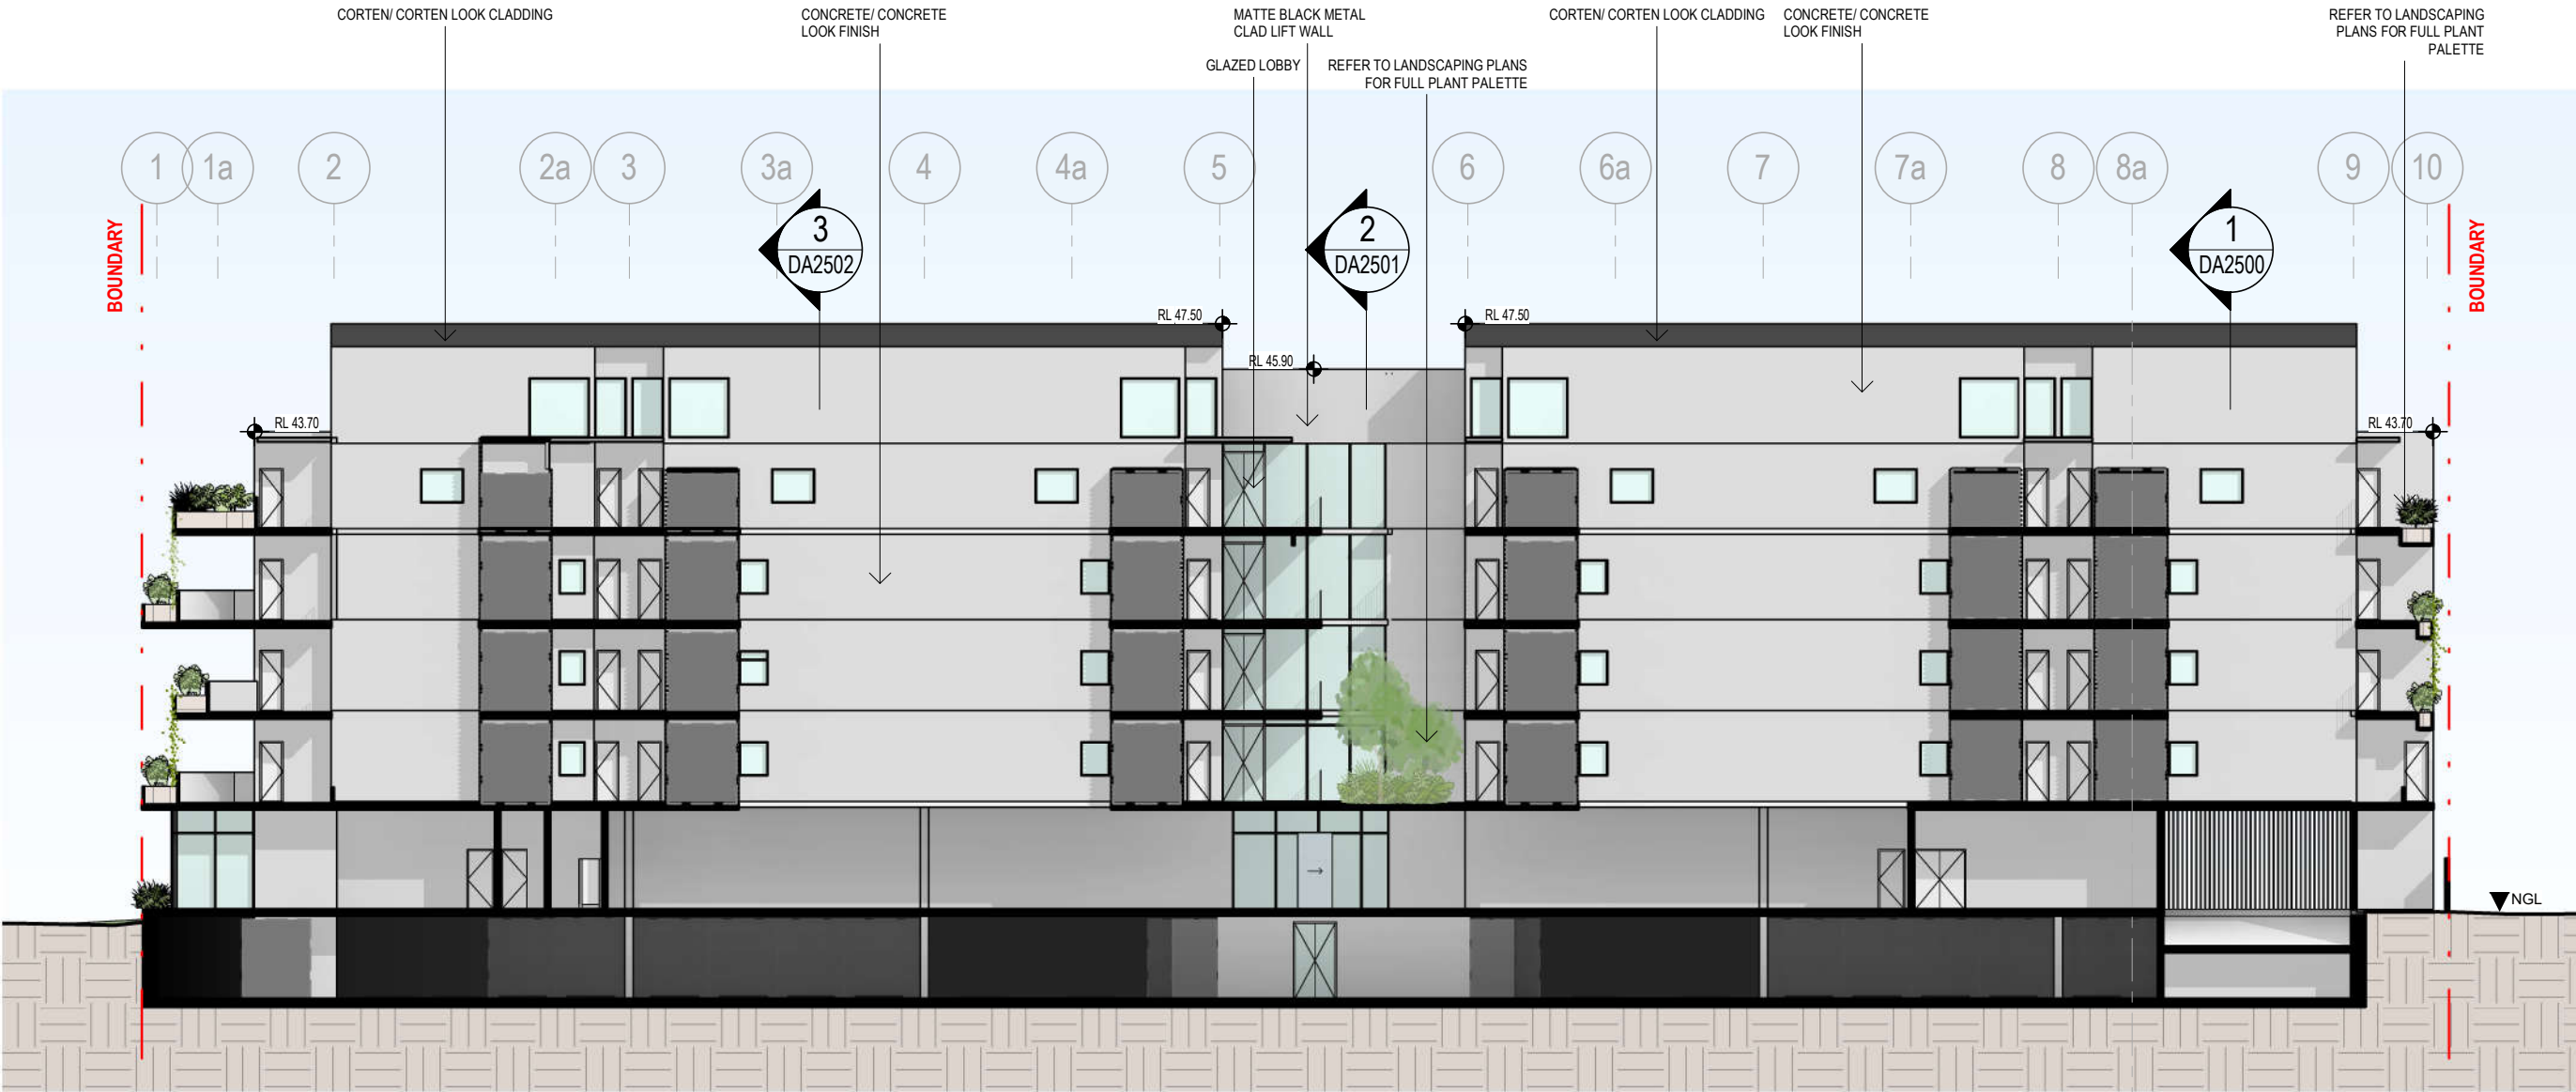

ROOF	▽
RL 46.700	
L05	▽
RL 43.500	
L04	▽
RL 40.300	
L03	▽
RL 37.100	
L02	▽
RL 33.900	
L01	▽
RL 30.700	
GROUND	▽
RL 26.900	
BASEMENT	▽
RL 23.750	

©architectus™

Architectus Australia Pty Ltd is the owner of the copyright subsisting in these drawings, plans, designs and specifications. They must not be used, reproduced or copied, in whole or in part, nor may the information, ideas and concepts therein contained (which are confidential to Architectus Australia Pty Ltd) be disclosed to any person without the prior written consent of that company.

Nominated Architect
Ray Brown, NSWARB 6359

Do not scale drawings. Verify all dimensions on site

issue	amendment	date
A	DA SUBMISSION	25/03/2021



architectus™

Adelaide
Brisbane
Melbourne
Sydney
Perth

Architectus Perth
QV1 Upper Plaza West
250 St. Georges Terrace
Perth WA 6000
T (61 8) 9412 8355

perth@architectus.com.au
ABN 90 131 245 684

checked AS
drawn KB
scale 1:250 @ A3

project 10 MORLEY DRIVE, TUART HILL

drawing

ELEVATION 05

project no 200611

issue

drawing no. DA2004 A

26/03/2021 12:13:43 PM



ROOF	▽
RL 46.700	
L05	▽
RL 43.500	
L04	▽
RL 40.300	
L03	▽
RL 37.100	
L02	▽
RL 33.900	
L01	▽
RL 30.700	
GROUND	▽
RL 26.900	
BASEMENT	▽
RL 23.750	

©architectus™

Architectus Australia Pty Ltd is the owner of the copyright subsisting in these drawings, plans, designs and specifications. They must not be used, reproduced or copied, in whole or in part, nor may the information, ideas and concepts therein contained (which are confidential to Architectus Australia Pty Ltd) be disclosed to any person without the prior written consent of that company.

Nominated Architect
Ray Brown, NSWARB 6359

Do not scale drawings. Verify all dimensions on site

issue	amendment	date
A	DA SUBMISSION	25/03/2021

DEPARTMENT OF PLANNING, LANDS AND HERITAGE	
DATE	FILE
07-Apr-2021	SDAU-007-20

architectus™

Adelaide
Brisbane
Melbourne
Sydney
Perth

Architectus Perth
QV1 Upper Plaza West
250 St. Georges Terrace
Perth WA 6000
T (61 8) 9412 8355

perth@architectus.com.au
ABN 90 131 245 684

checked AS
drawn KB
scale 1 : 250@A3

project 10 MORLEY DRIVE, TUART HILL

drawing

ELEVATION 06

project no 200611

drawing no. DA2005 issue A

26/03/2021 12:15:34 PM



©architectus™

Architectus Australia Pty Ltd is the owner of the copyright subsisting in these drawings, plans, designs and specifications. They must not be used, reproduced or copied, in whole or in part, nor may the information, ideas and concepts therein contained (which are confidential to Architectus Australia Pty Ltd) be disclosed to any person without the prior written consent of that company.

Nominated Architect
Ray Brown, NSWARB 6359

Do not scale drawings. Verify all dimensions on site

issue	amendment	date
A	DA SUBMISSION	25/03/2021



architectus™

Adelaide
Brisbane
Melbourne
Sydney
Perth

Architectus Perth
QV1 Upper Plaza West
250 St. Georges Terrace
Perth WA 6000
T (61 8) 9412 8355

perth@architectus.com.au
ABN 90 131 245 684

checked
drawn
scale

AS
FMK
A3
1:250 @

project 10 MORLEY DRIVE, TUART HILL


drawing

SECTION 01

project no 200611

drawing no. DA2500 issue A

26/03/2021 12:15:59 PM

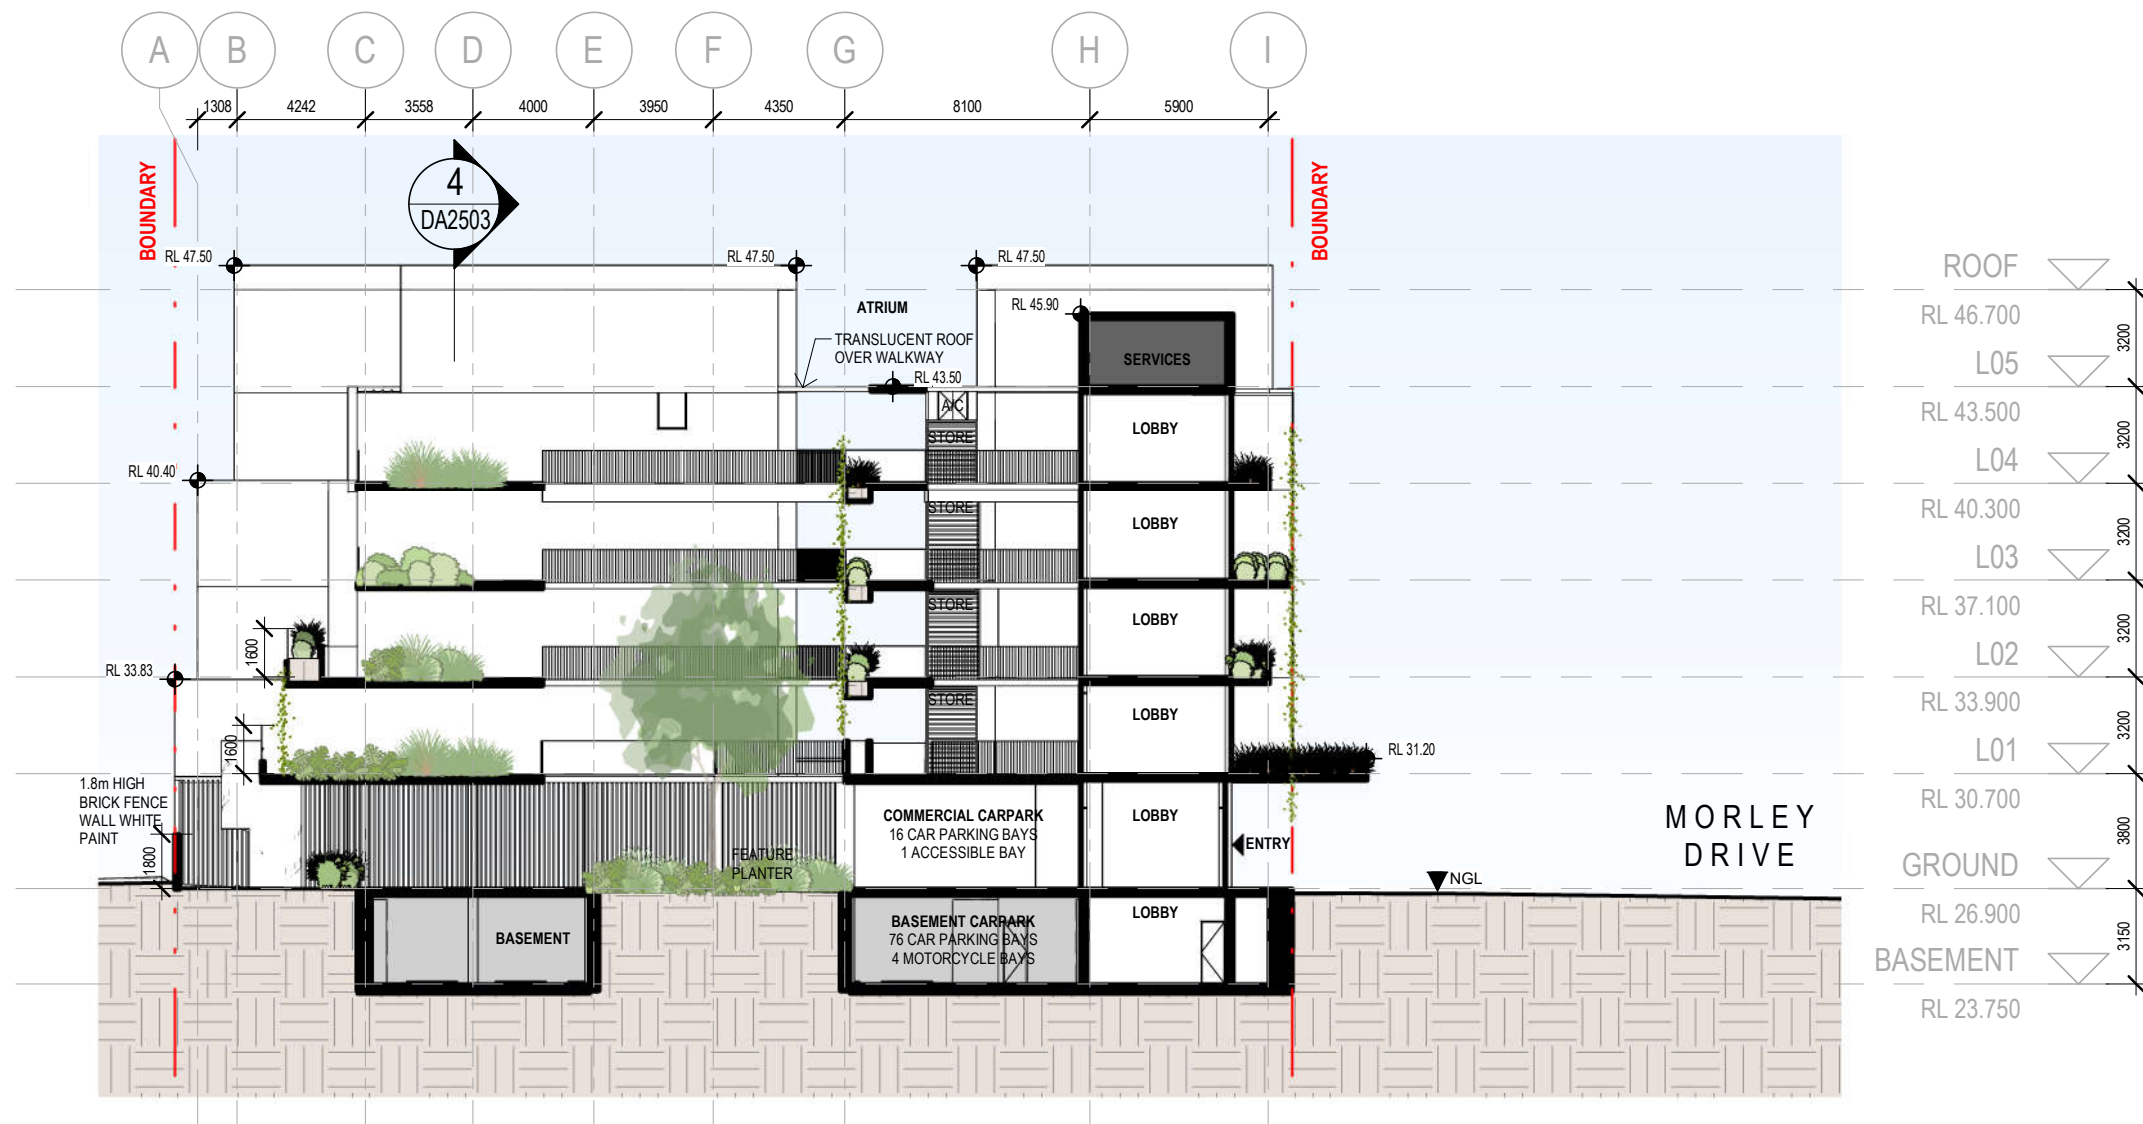

©architectus™

Architectus Australia Pty Ltd is the owner of the copyright subsisting in these drawings, plans, designs and specifications. They must not be used, reproduced or copied, in whole or in part, nor may the information, ideas and concepts therein contained (which are confidential to Architectus Australia Pty Ltd) be disclosed to any person without the prior written consent of that company.

Nominated Architect
Ray Brown, NSWARB 6359

Do not scale drawings. Verify all dimensions on site

issue	amendment	date
A	DA SUBMISSION	25/03/2021



architectus™

Adelaide
Brisbane
Melbourne
Sydney
Perth

Architectus Perth
QV1 Upper Plaza West
250 St. Georges Terrace
Perth WA 6000
T (61 8) 9412 8355

perth@architectus.com.au
ABN 90 131 245 684

checked AS
drawn FMK
scale 1:250 @ A3

project 10 MORLEY DRIVE, TUART HILL

drawing


SECTION 02

project no 200611

issue

drawing no. DA2501 A

26/03/2021 12:16:17 PM

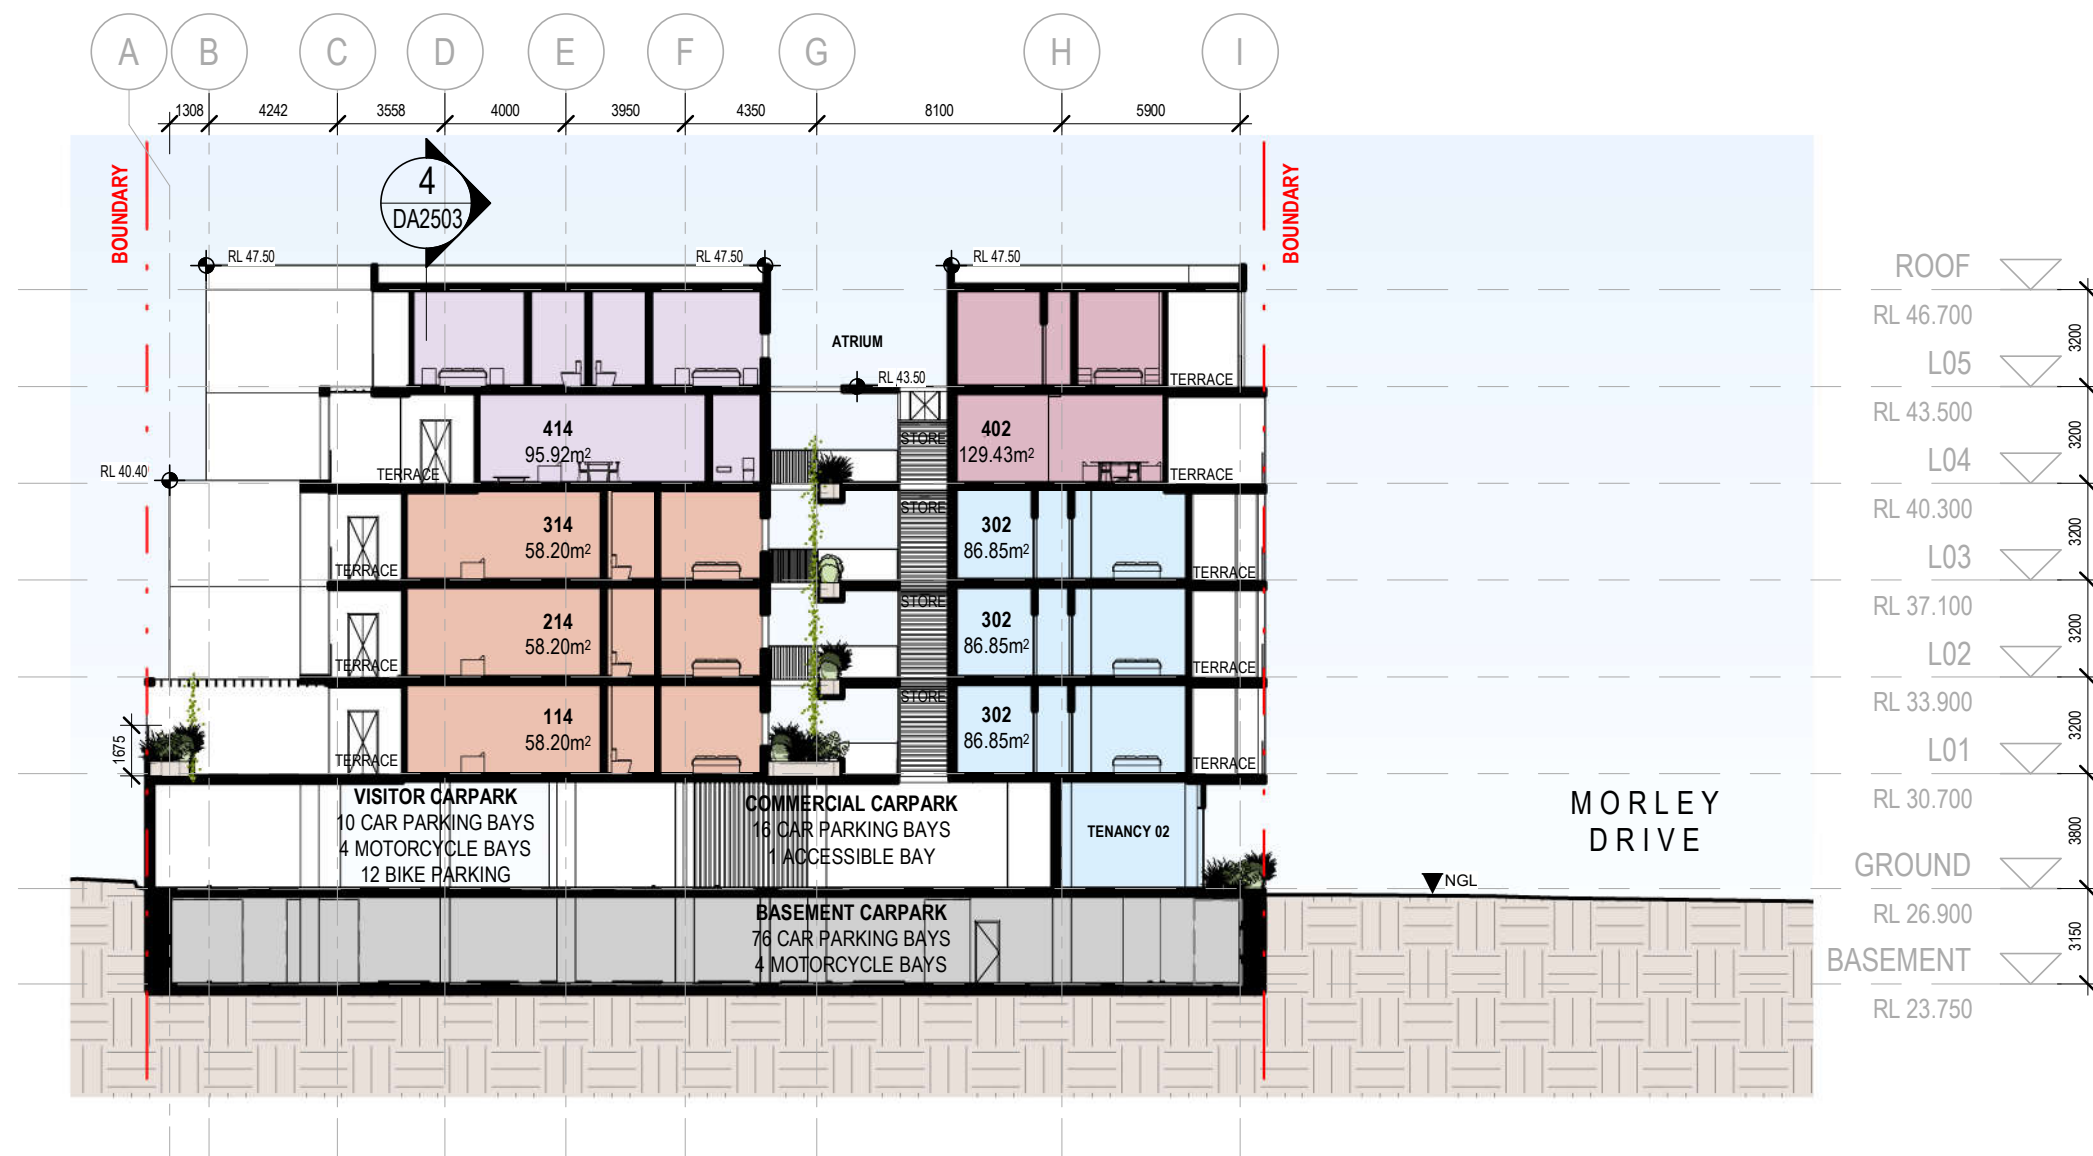

©architectus™

Architectus Australia Pty Ltd is the owner of the copyright subsisting in these drawings, plans, designs and specifications. They must not be used, reproduced or copied, in whole or in part, nor may the information, ideas and concepts therein contained (which are confidential to Architectus Australia Pty Ltd) be disclosed to any person without the prior written consent of that company.

Nominated Architect
Ray Brown, NSWARB 6359

Do not scale drawings. Verify all dimensions on site

issue	amendment	date
A	DA SUBMISSION	25/03/2021



architectus™

Adelaide
Brisbane
Melbourne
Sydney
Perth

Architectus Perth
QV1 Upper Plaza West
250 St. Georges Terrace
Perth WA 6000
T (61 8) 9412 8355

perth@architectus.com.au
ABN 90 131 245 684

checked
drawn
scale

Checker
Author
@ A3
1:250

project 10 MORLEY DRIVE, TUART HILL




drawing

SECTION 03

project no 200611

drawing no. DA2502 A

26/03/2021 12:16:30 PM

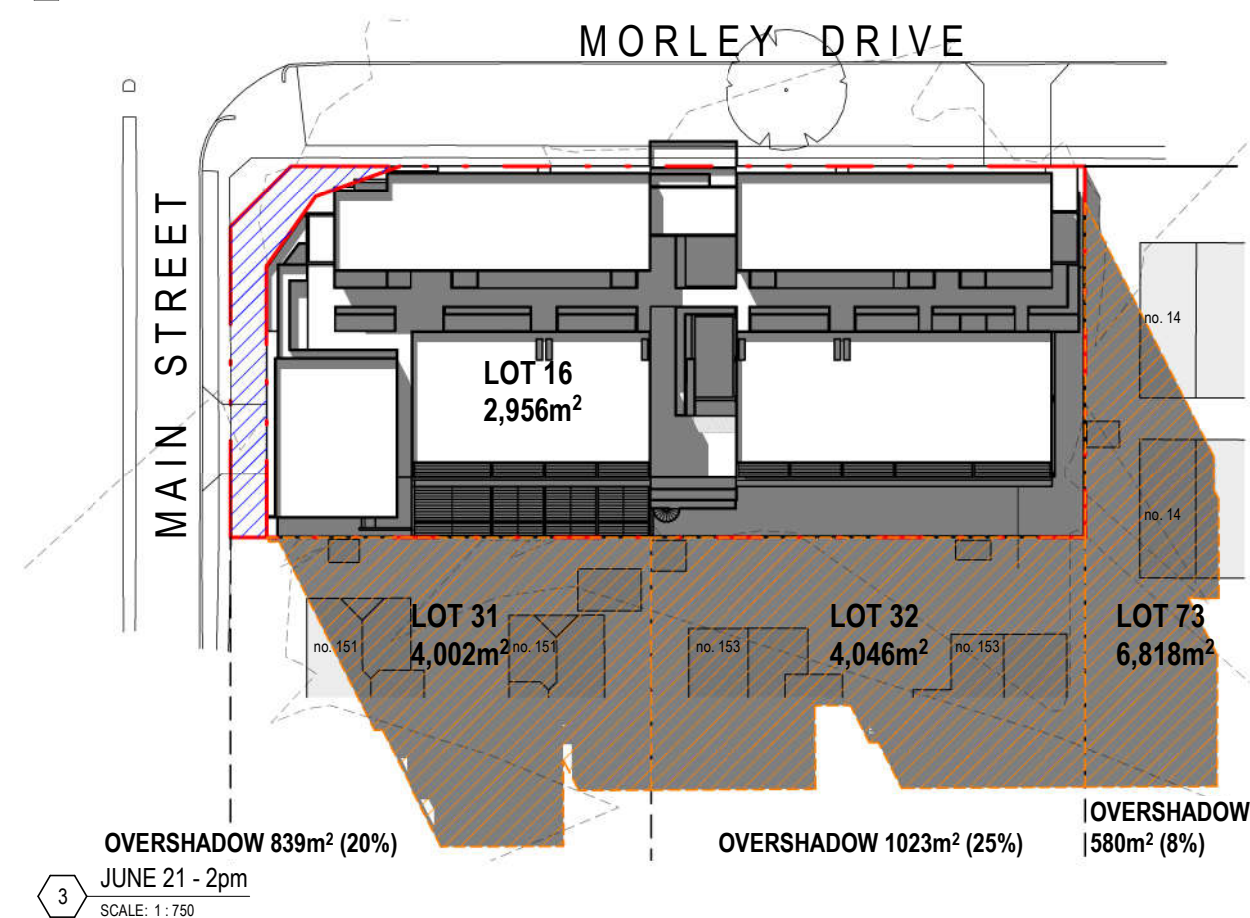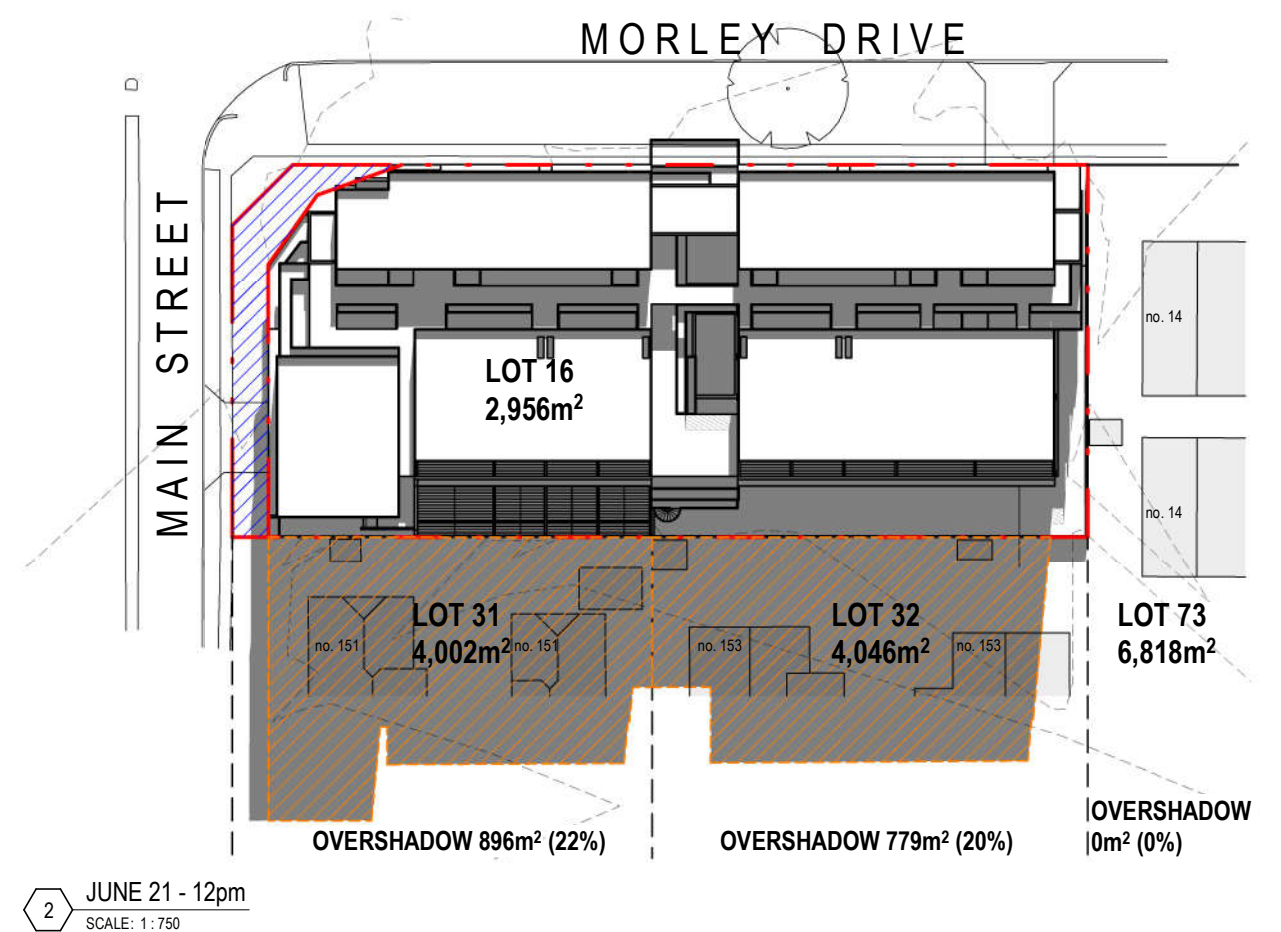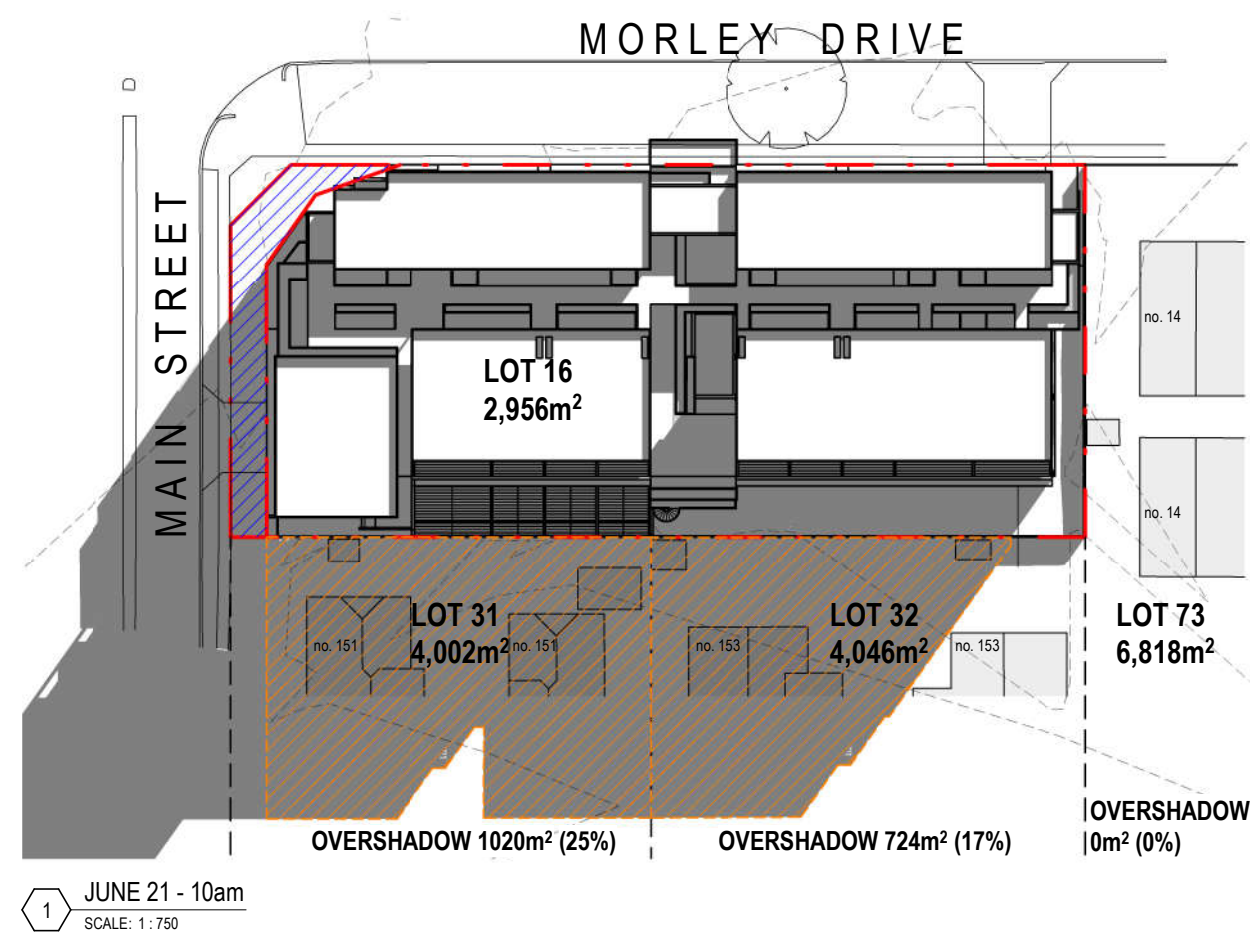


©architectus™

Architectus Australia Pty Ltd is the owner of the copyright subsisting in these drawings, plans, designs and specifications. They must not be used, reproduced or copied, in whole or in part, nor may the information, ideas and concepts therein contained (which are confidential to Architectus Australia Pty Ltd) be disclosed to any person without the prior written consent of that company.

Nominated Architect
Ray Brown, NSWARB 6359

Do not scale drawings. Verify all dimensions on site

issue	amendment	date
A	DA SUBMISSION	25/03/2021

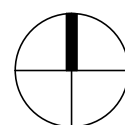

DEPARTMENT OF PLANNING, LANDS AND HERITAGE	
DATE	FILE
07-Apr-2021	SDAU-007-20

architectus™

Adelaide
Brisbane
Melbourne
Sydney
Perth

Architectus Perth
QV1 Upper Plaza West
250 St. Georges Terrace
Perth WA 6000
T (61 8) 9412 8355

perth@architectus.com.au
ABN 90 131 245 684

checked AS
drawn FMK
scale 1:750 @ A3


project 10 MORLEY DRIVE, TUART HILL

drawing SHADOW DIAGRAM 01 - JUNE 21


project no 200611

drawing no. DA4000 A


26/03/2021 12:18:33 PM

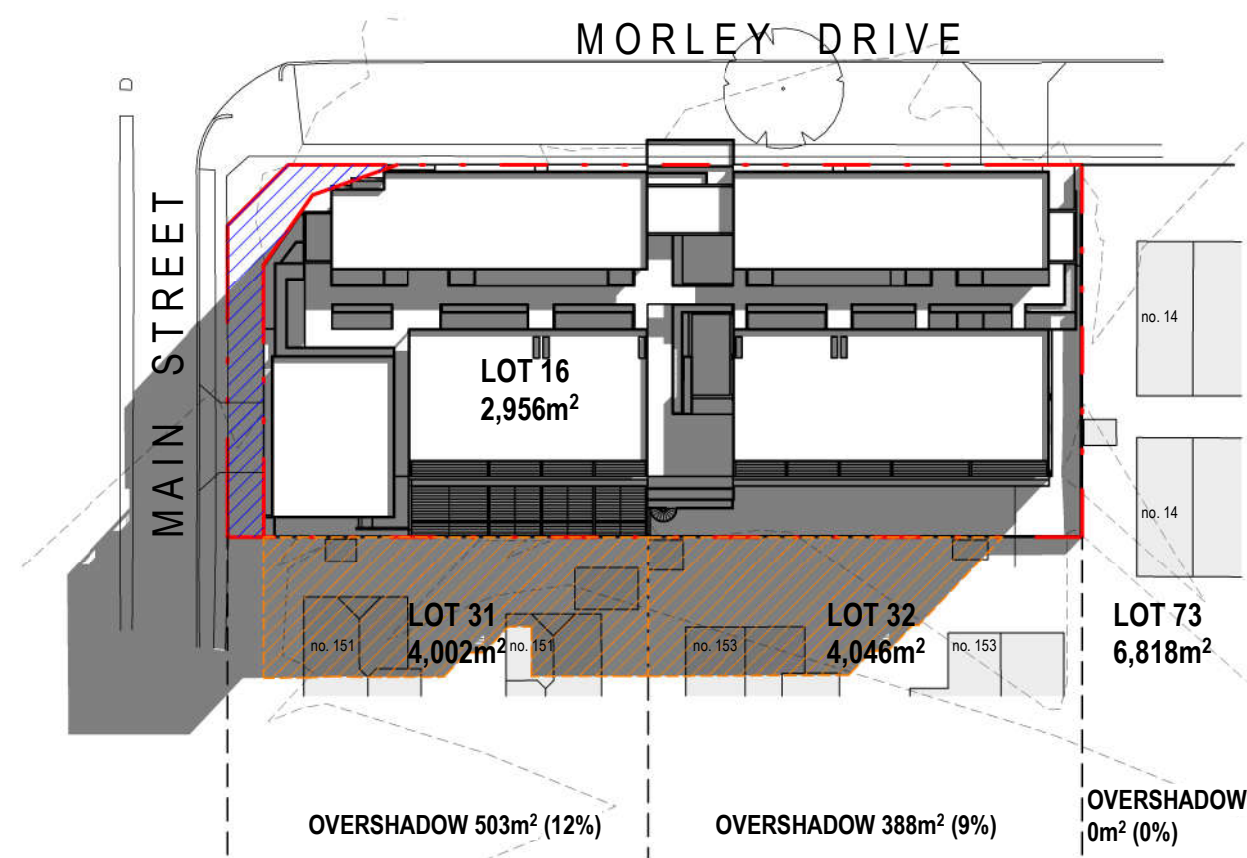

1 AUG 22 - 10am
SCALE: 1:750

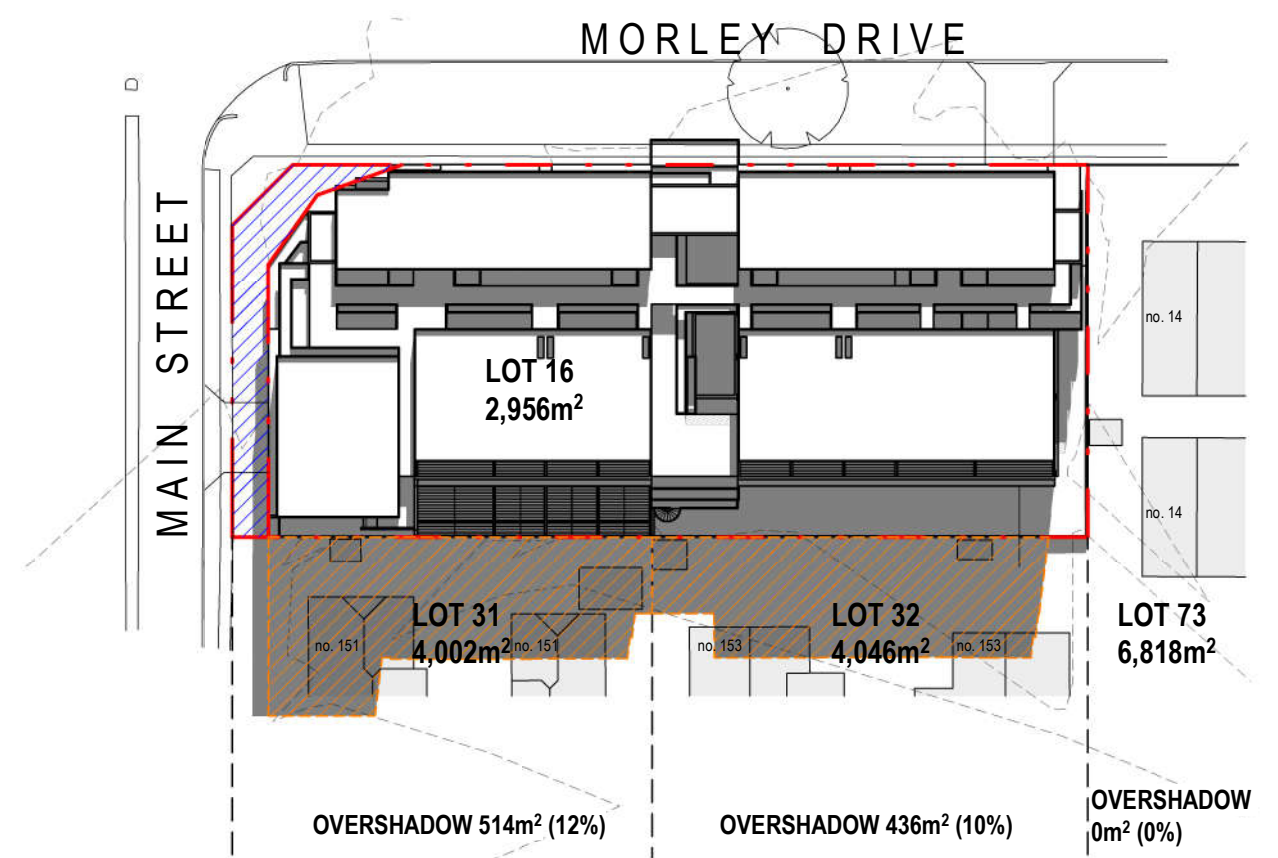

2 AUG 22 - 12pm
SCALE: 1:750

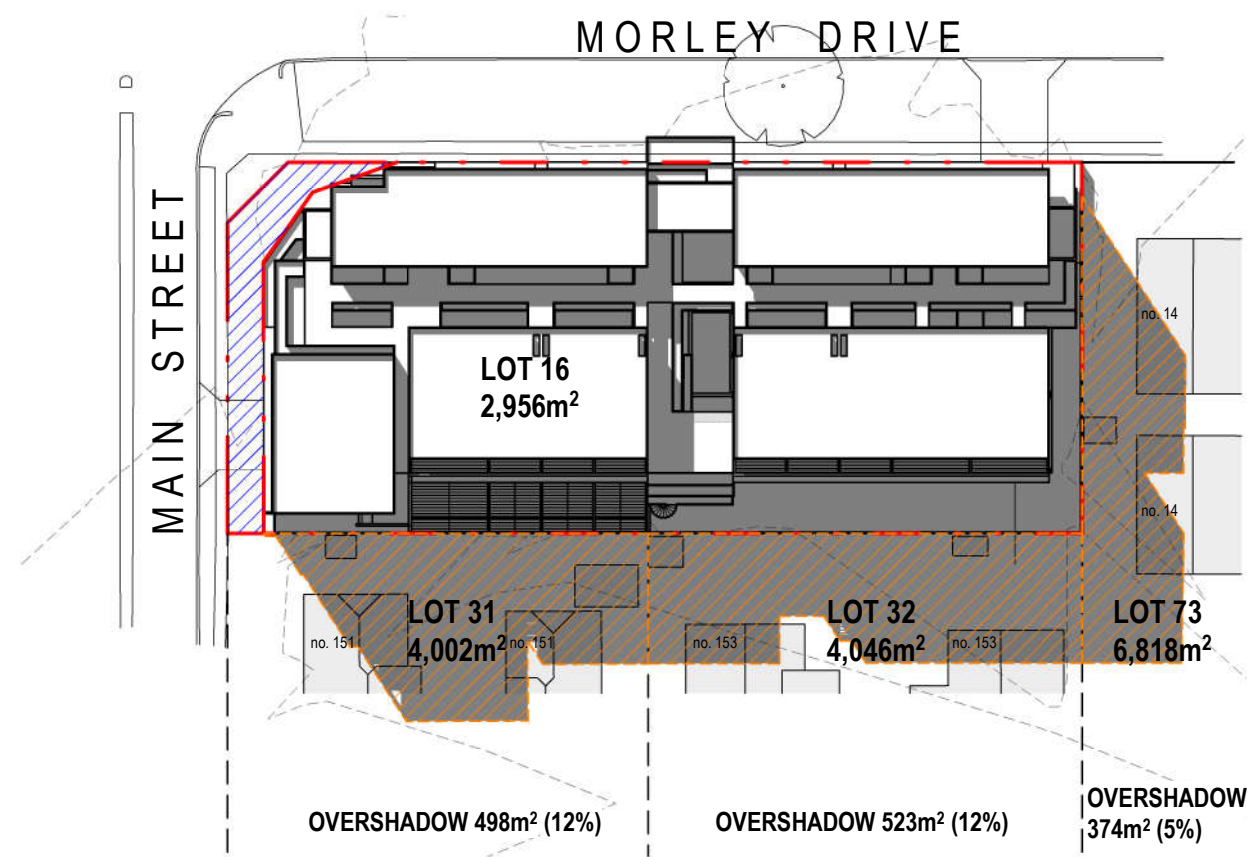

3 AUG 22 - 2pm
SCALE: 1:750


©architectus™

Architectus Australia Pty Ltd is the owner of the copyright subsisting in these drawings, plans, designs and specifications. They must not be used, reproduced or copied, in whole or in part, nor may the information, ideas and concepts therein contained (which are confidential to Architectus Australia Pty Ltd) be disclosed to any person without the prior written consent of that company.

Nominated Architect
Ray Brown, NSWARB 6359

Do not scale drawings. Verify all dimensions on site

issue	amendment	date
A	DA SUBMISSION	25/03/2021

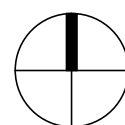

DEPARTMENT OF PLANNING, LANDS AND HERITAGE	
DATE	FILE
07-Apr-2021	SDAU-007-20

architectus™

Adelaide
Brisbane
Melbourne
Sydney
Perth

Architectus Perth
QV1 Upper Plaza West
250 St. Georges Terrace
Perth WA 6000
T (61 8) 9412 8355

perth@architectus.com.au
ABN 90 131 245 684

checked AS
drawn FMK
scale 1:750 @ A3


project 10 MORLEY DRIVE, TUART HILL

drawing SHADOW DIAGRAM 02 - AUG 22


project no 200611

drawing no. DA4001 issue A


26/03/2021 12:19:58 PM

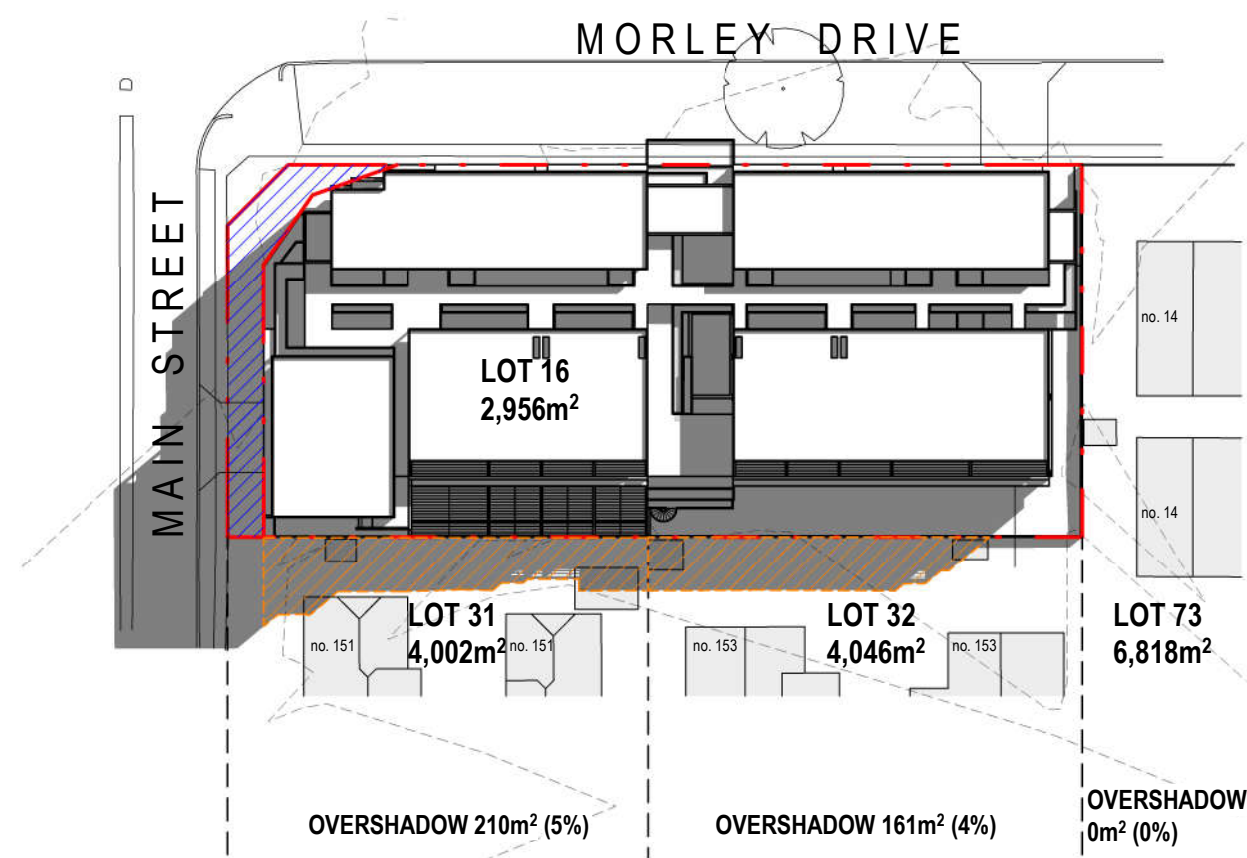

1 SEPT 22 - 10am
SCALE: 1 : 750

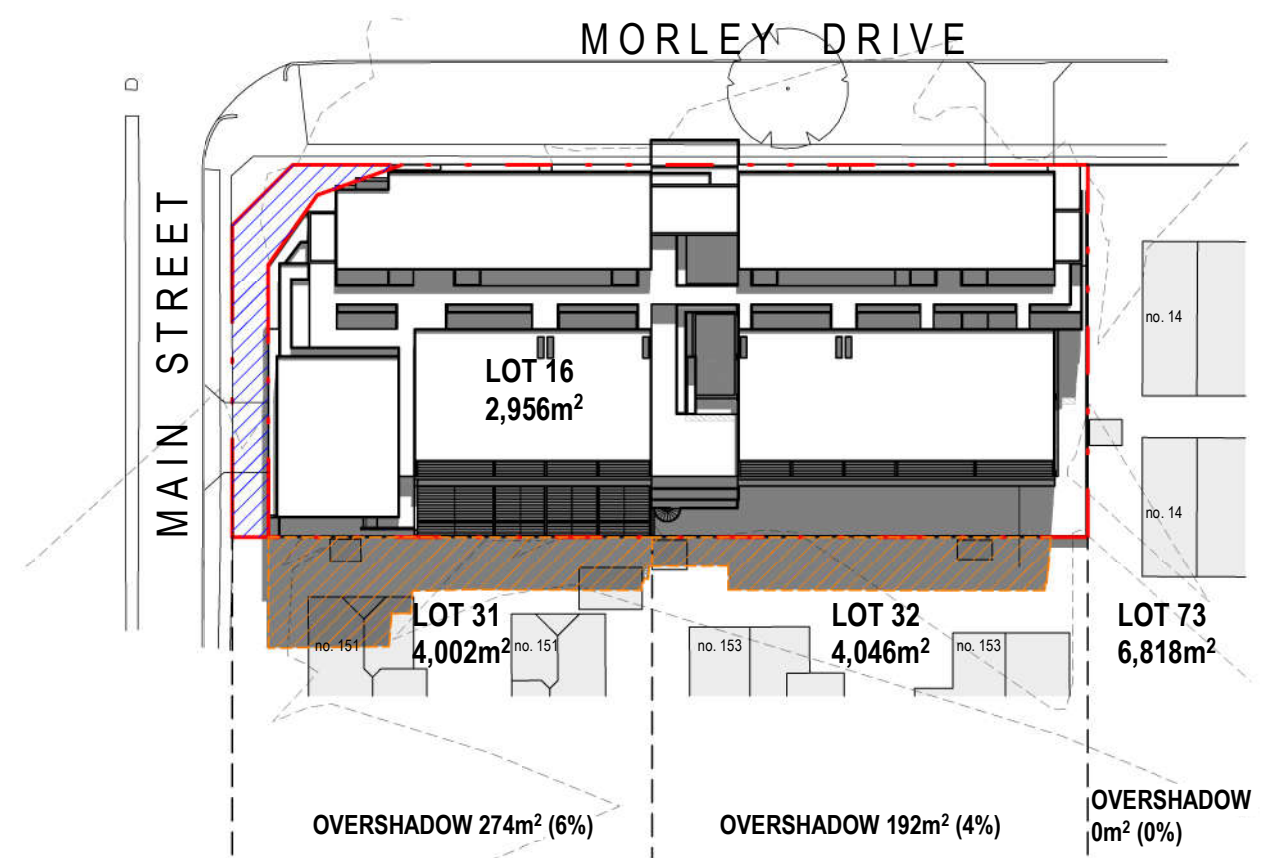

2 SEPT 22 - 12pm
SCALE: 1 : 750

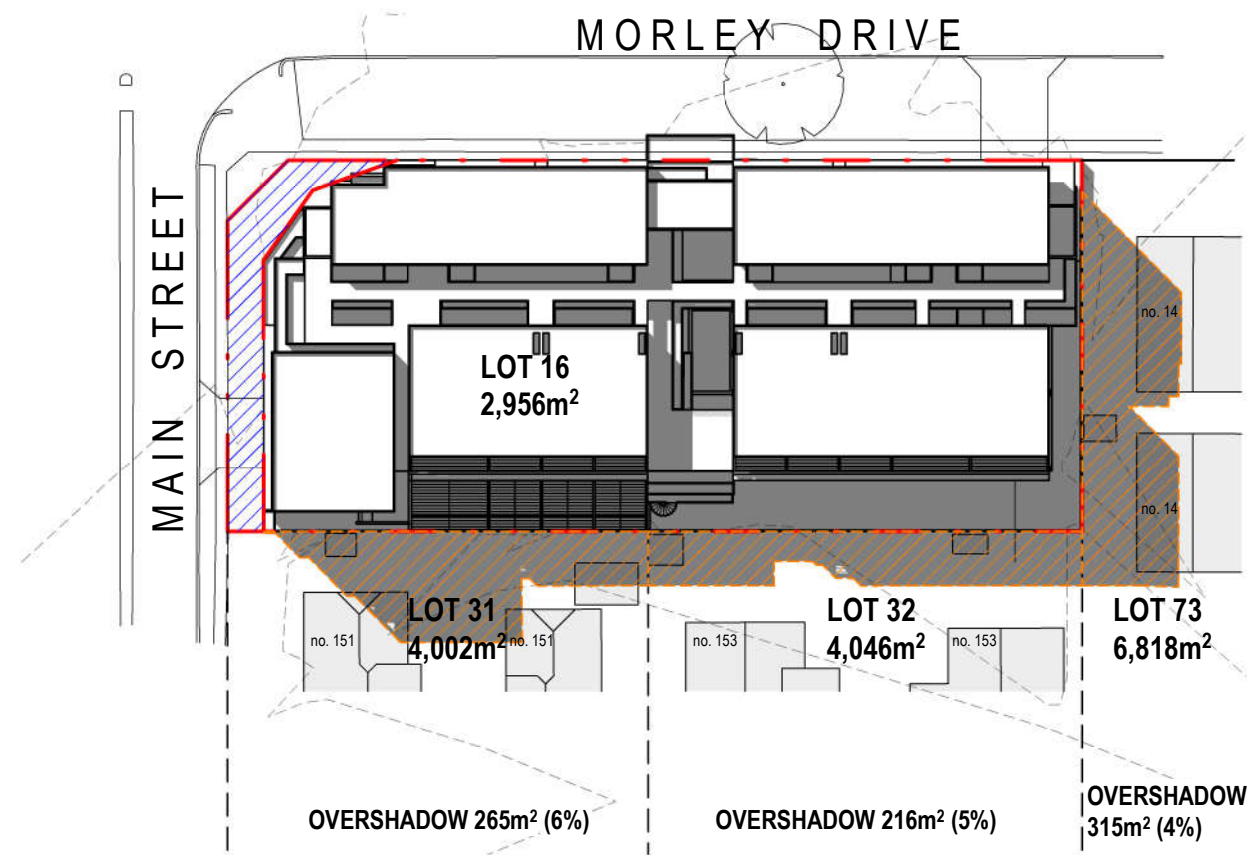

3 SEPT 22 - 2pm
SCALE: 1 : 750


©architectus™

Architectus Australia Pty Ltd is the owner of the copyright subsisting in these drawings, plans, designs and specifications. They must not be used, reproduced or copied, in whole or in part, nor may the information, ideas and concepts therein contained (which are confidential to Architectus Australia Pty Ltd) be disclosed to any person without the prior written consent of that company.

Nominated Architect
Ray Brown, NSWARB 6359

Do not scale drawings. Verify all dimensions on site

issue	amendment	date
A	DA SUBMISSION	25/03/2021

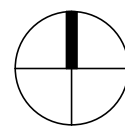

DEPARTMENT OF PLANNING, LANDS AND HERITAGE	
DATE	FILE
07-Apr-2021	SDAU-007-20

architectus™

Adelaide
Brisbane
Melbourne
Sydney
Perth

Architectus Perth
QV1 Upper Plaza West
250 St. Georges Terrace
Perth WA 6000
T (61 8) 9412 8355

perth@architectus.com.au
ABN 90 131 245 684

checked AS
drawn FMK
scale 1:750 @ A3


project 10 MORLEY DRIVE, TUART HILL

drawing SHADOW DIAGRAM 03 - SEPT 22


project no 200611

drawing no. DA4002 issue A


26/03/2021 12:21:13 PM

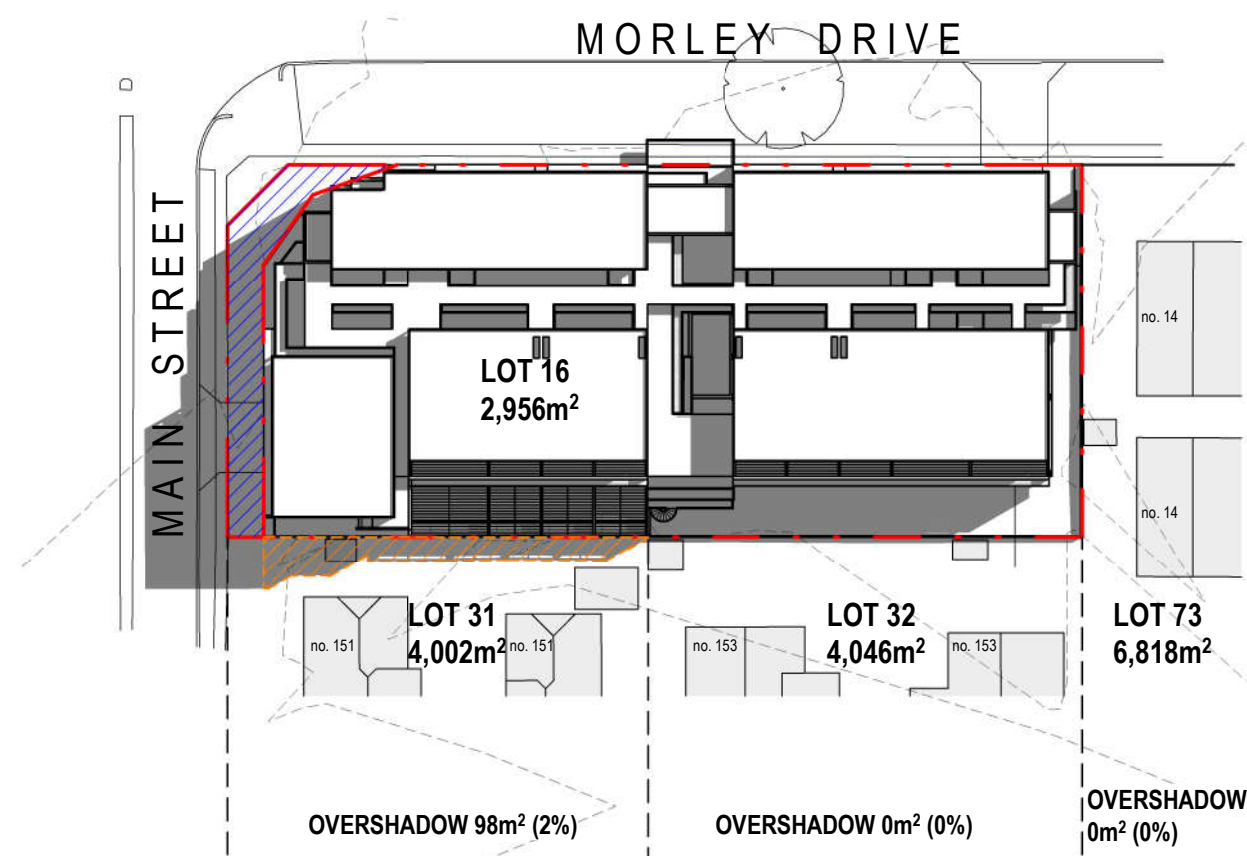

1 OCT 22 - 10am
SCALE: 1:750

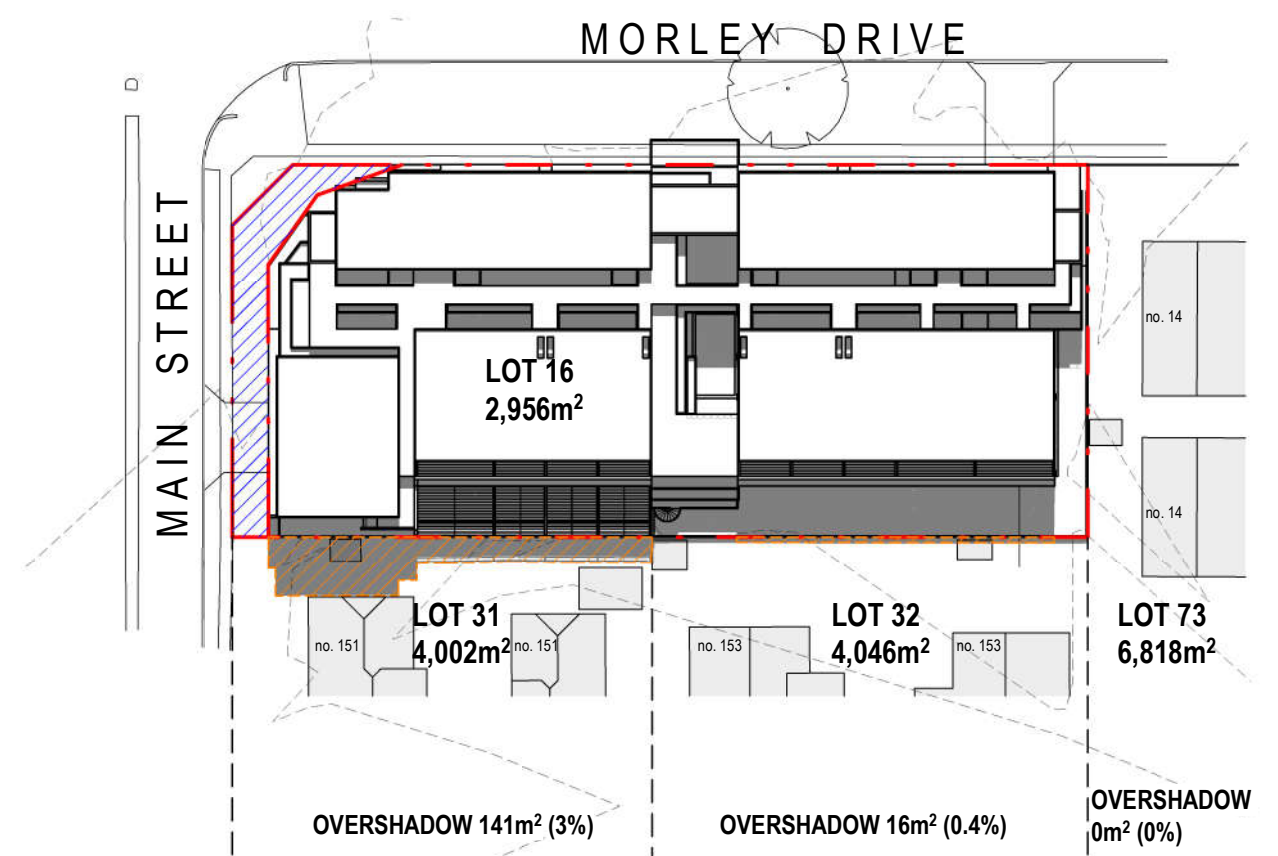

2 OCT 22 - 12pm
SCALE: 1:750

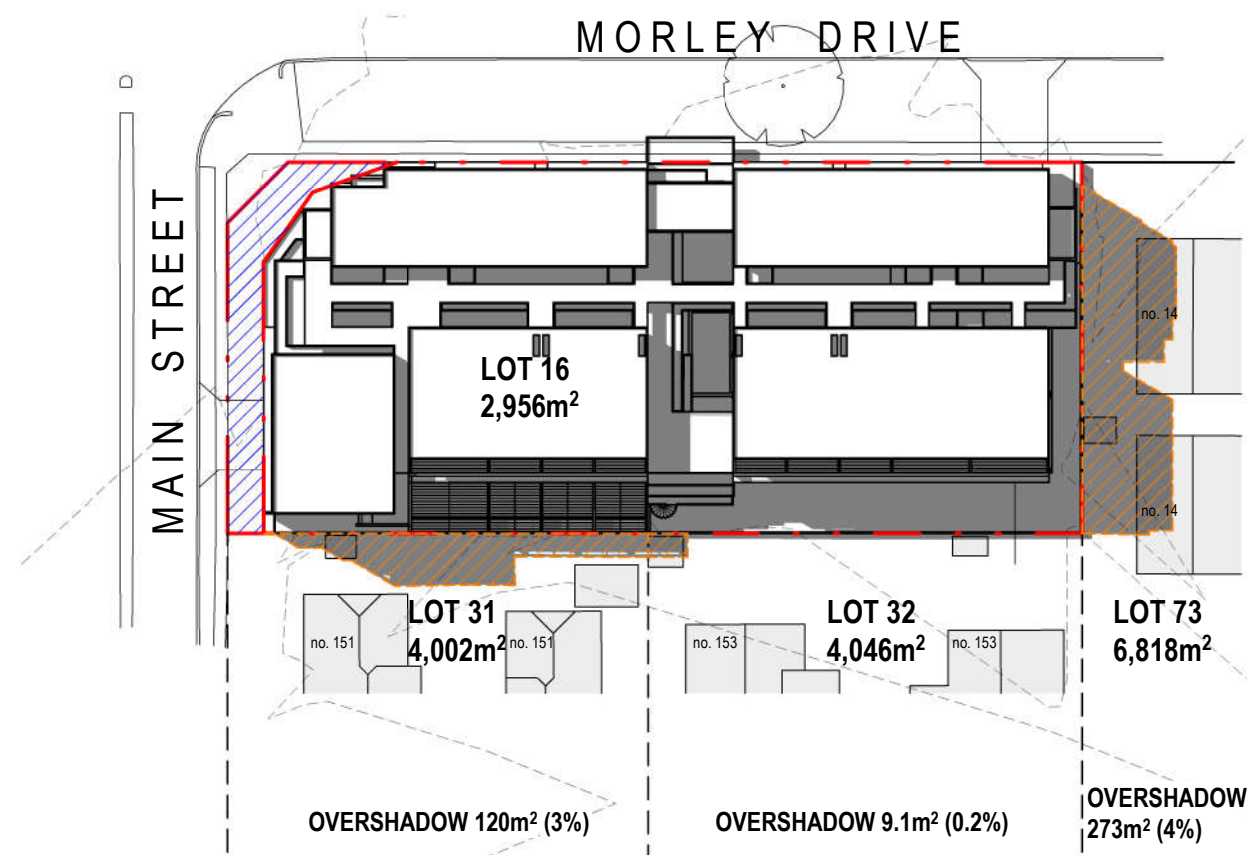

3 OCT 22 - 2pm
SCALE: 1:750


©architectus™

Architectus Australia Pty Ltd is the owner of the copyright subsisting in these drawings, plans, designs and specifications. They must not be used, reproduced or copied, in whole or in part, nor may the information, ideas and concepts therein contained (which are confidential to Architectus Australia Pty Ltd) be disclosed to any person without the prior written consent of that company.

Nominated Architect
Ray Brown, NSWARB 6359

Do not scale drawings. Verify all dimensions on site

issue	amendment	date
A	DA SUBMISSION	25/03/2021

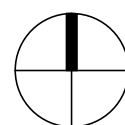

DEPARTMENT OF PLANNING, LANDS AND HERITAGE	
DATE	FILE
07-Apr-2021	SDAU-007-20

architectus™

Adelaide
Brisbane
Melbourne
Sydney
Perth

Architectus Perth
QV1 Upper Plaza West
250 St. Georges Terrace
Perth WA 6000
T (61 8) 9412 8355

perth@architectus.com.au
ABN 90 131 245 684

checked AS
drawn FMK
scale 1:750 @ A3

project 10 MORLEY DRIVE, TUART HILL

drawing SHADOW DIAGRAM 04 - OCT 22


project no 200611

drawing no. DA4003 A


26/03/2021 12:22:15 PM




1 PLOT RATIO AREA - BASEMENT PLAN
SCALE: 1:500

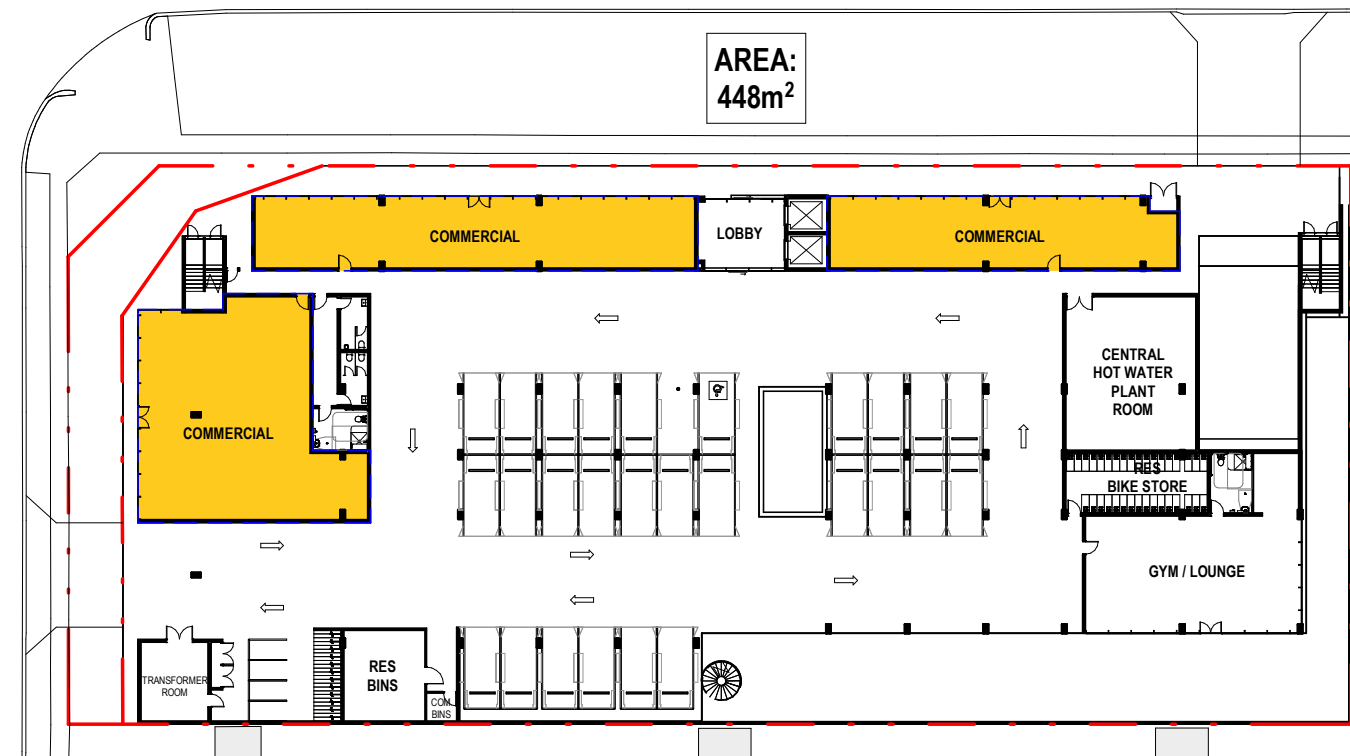

2 PLOT RATIO AREA - GROUND FLOOR
SCALE: 1:500

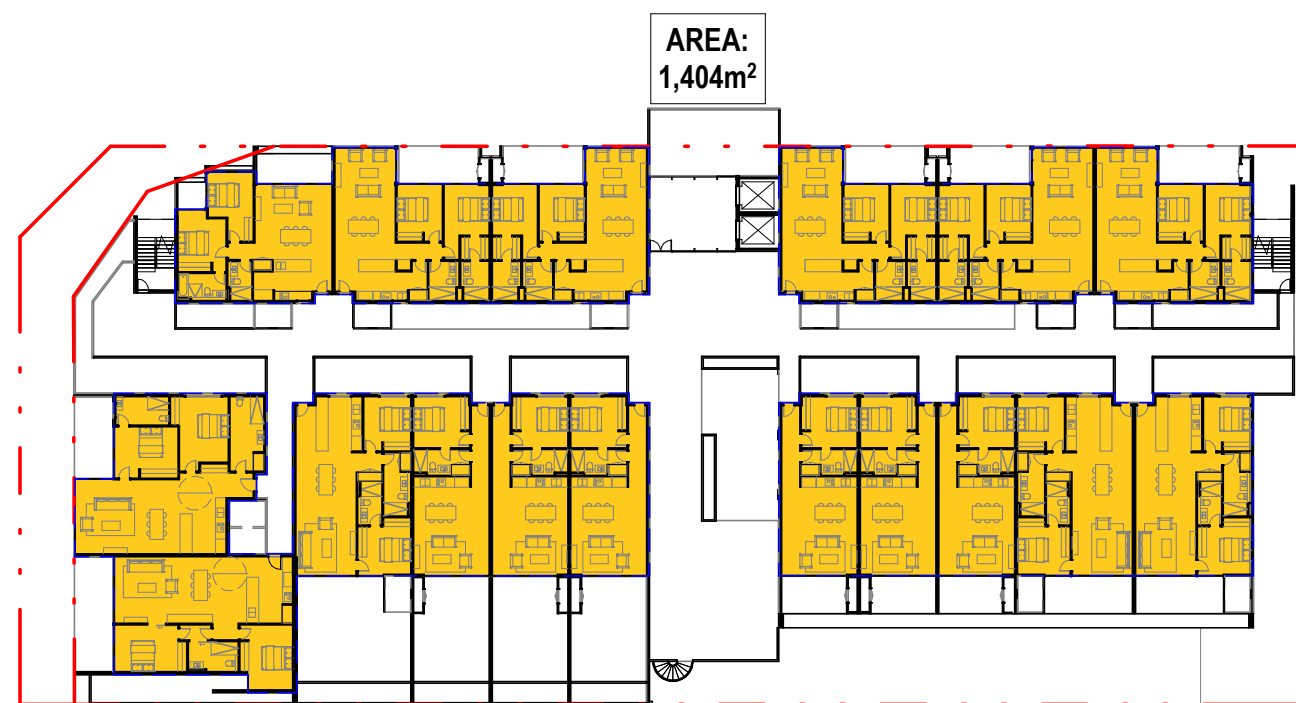

3 PLOT RATIO AREA - L01
SCALE: 1:500

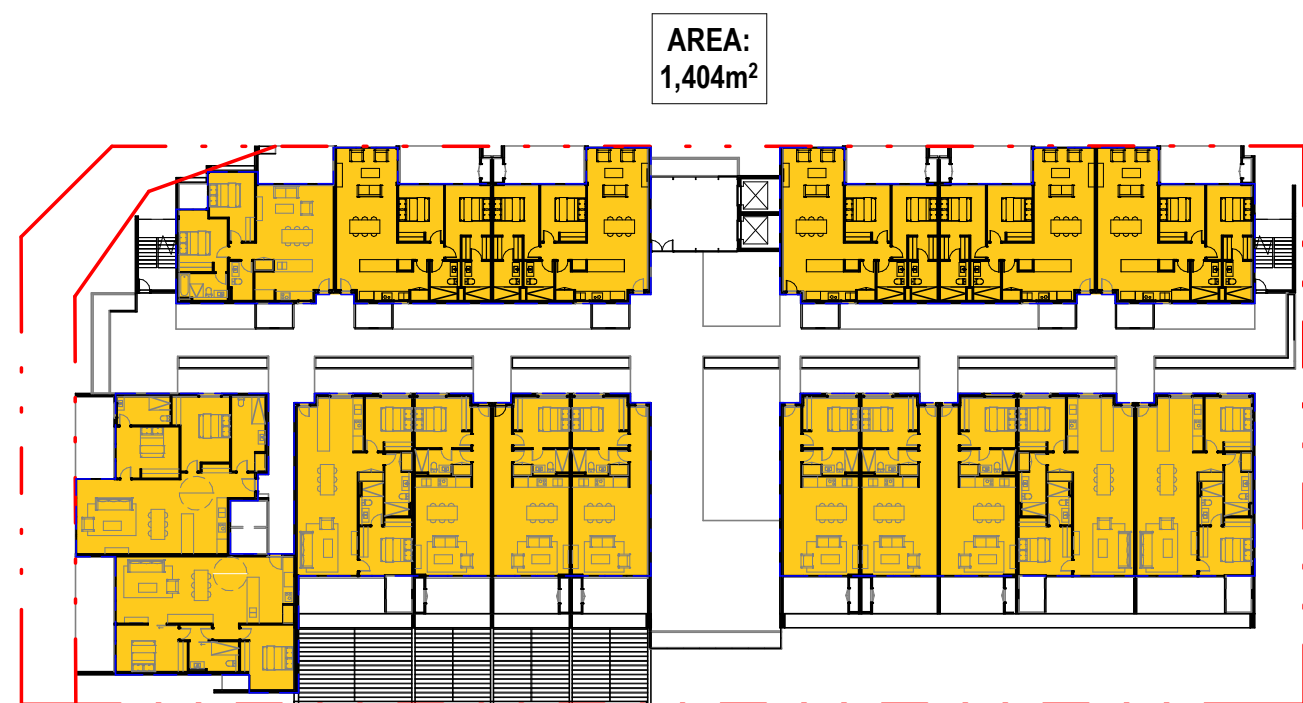

4 PLOT RATIO AREA - L02
SCALE: 1:500


©architectus™

Architectus Australia Pty Ltd is the owner of the copyright subsisting in these drawings, plans, designs and specifications. They must not be used, reproduced or copied, in whole or in part, nor may the information, ideas and concepts therein contained (which are confidential to Architectus Australia Pty Ltd) be disclosed to any person without the prior written consent of that company.

Nominated Architect
Ray Brown, NSWARB 6359

Do not scale drawings. Verify all dimensions on site

issue	amendment	date
A	DA SUBMISSION	25/03/2021

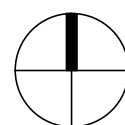

DEPARTMENT OF PLANNING, LANDS AND HERITAGE	
DATE	FILE
07-Apr-2021	SDAU-007-20

architectus™

Adelaide
Brisbane
Melbourne
Sydney
Perth

checked
drawn
scale

Architectus Perth
QV1 Upper Plaza West
250 St. Georges Terrace
Perth WA 6000
T (61 8) 9412 8355

perth@architectus.com.au
ABN 90 131 245 684

AS
FMK
A3
1:500 @

project 10 MORLEY DRIVE, TUART HILL

drawing


PLOT RATIO AREA 01

project no 200611


issue A

drawing no. DA4010

26/03/2021 12:22:37 PM

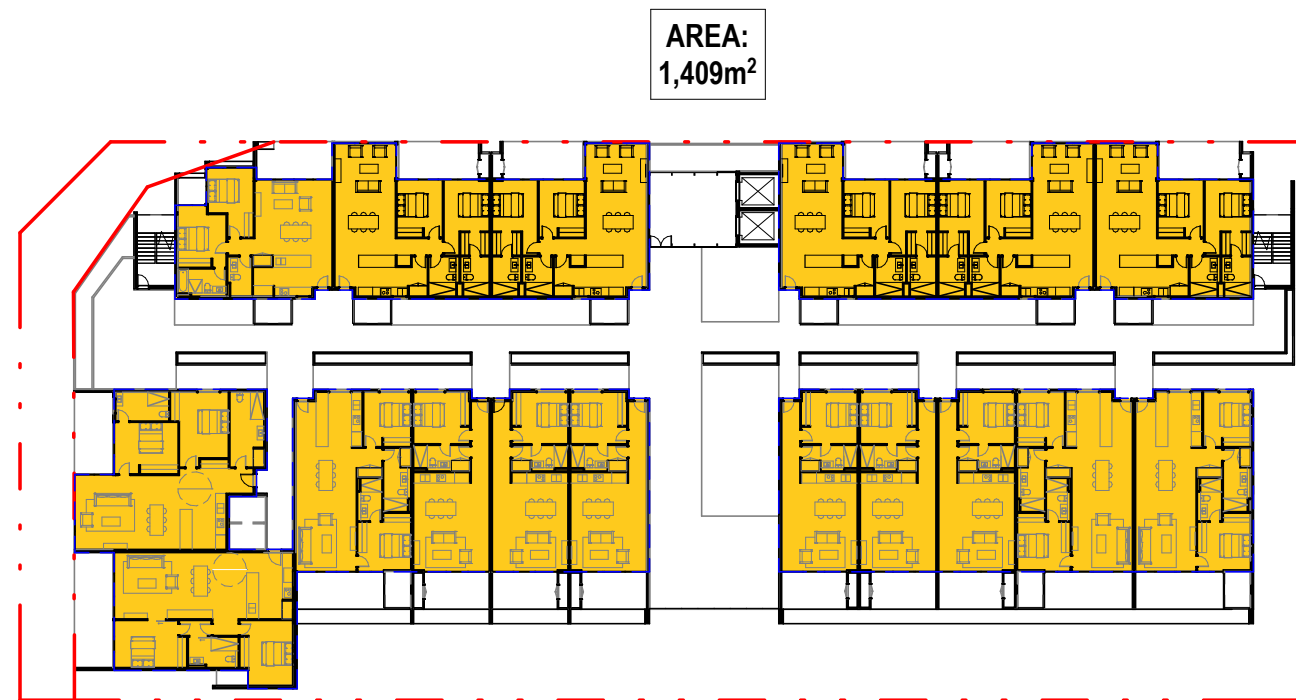

1 PLOT RATIO AREA - L03
SCALE: 1:500

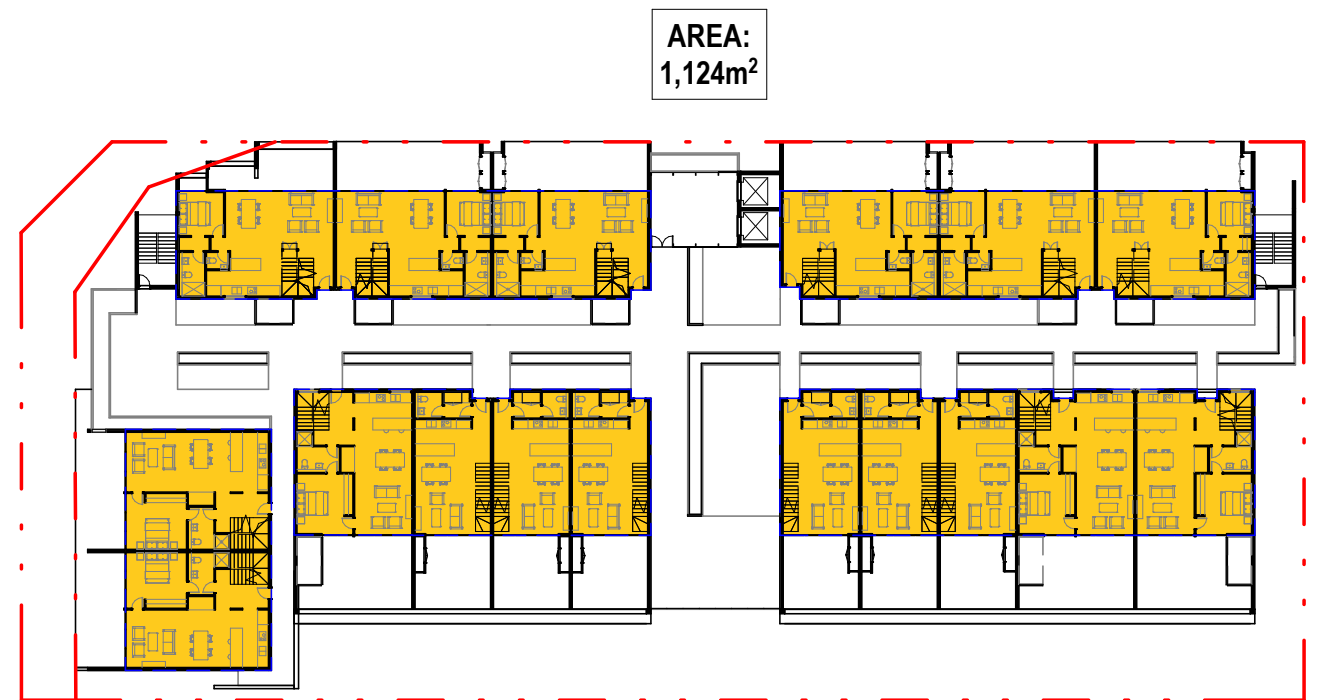

2 PLOT RATIO AREA - L04
SCALE: 1:500



3 PLOT RATIO AREA - L05
SCALE: 1:500

PLOT RATIO

SITE AREA	2,956m ²
-----------	---------------------

FLOOR:	AREA:
BASEMENT	0m ²
GROUND	448m ²
L01	1,409m ²
L02	1,409m ²
L03	1,409m ²
L04	1,124m ²
L05	1,043m ²
TOTAL:	6,842m²

Plot Ratio Area: the gross total area of all floors of buildings on a development site, including the area of any internal and external walls but not including:

- * The areas of any lift shafts.
- * Stairs or stair landings common to two or more dwellings.
- * Machinery, air conditioning and equipment rooms.
- * Space that is wholly below natural ground level.
- * Areas used exclusively for the parking of wheeled vehicles at or below natural ground level;
- * Storerooms.
- * Lobbies, bin storage areas, passageways to bin storage areas or amenities areas common to more than one dwelling.
- * Balconies, eaves, verandahs, courtyards and roof terraces.

$$\frac{6,842\text{m}^2 \text{ (TOTAL m}^2\text{)}}{2,956\text{m}^2 \text{ (SITE m}^2\text{)}} = 2.30:1 \text{ (PLOT RATIO)}$$


©architectus™

Architectus Australia Pty Ltd is the owner of the copyright subsisting in these drawings, plans, designs and specifications. They must not be used, reproduced or copied, in whole or in part, nor may the information, ideas and concepts therein contained (which are confidential to Architectus Australia Pty Ltd) be disclosed to any person without the prior written consent of that company.

Nominated Architect
Ray Brown, NSWARB 6359

Do not scale drawings. Verify all dimensions on site

issue	amendment	date
A	DA SUBMISSION	25/03/2021

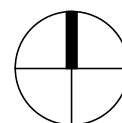

DEPARTMENT OF PLANNING, LANDS AND HERITAGE	
DATE	FILE
07-Apr-2021	SDAU-007-20

architectus™

Adelaide
Brisbane
Melbourne
Sydney
Perth

Architectus Perth
QV1 Upper Plaza West
250 St. Georges Terrace
Perth WA 6000
T (61 8) 9412 8355

perth@architectus.com.au
ABN 90 131 245 684

checked AS
drawn FMK
scale 1:500 @ A3

project 10 MORLEY DRIVE, TUART HILL

drawing

PLOT RATIO AREA 02

project no 200611

issue

drawing no. DA4011 A

26/03/2021 12:23:00 PM

APARTMENT SCH.				
APT. No.	APT. TYPE	APT. FUNCTION	APT. AREA	APT. STORE
101	2B	2 BEDROOM	76.41 m²	4m ²
102	2A	2 BEDROOM	86.85 m²	4m ²
103	2A	2 BEDROOM	86.85 m²	4m ²
104	2A	2 BEDROOM	86.85 m²	4m ²
105	2A	2 BEDROOM	86.85 m²	4m ²
106	2A	2 BEDROOM	86.85 m²	4m ²
107	2C	2 BEDROOM	88.89 m²	4m ²
108	2C	2 BEDROOM	88.89 m²	4m ²
109	1A	1 BEDROOM	58.20 m²	3.7m ²
110	1A	1 BEDROOM	58.20 m²	3.7m ²
111	1A	1 BEDROOM	58.20 m²	3.7m ²
112	1A	1 BEDROOM	58.20 m²	3.7m ²
113	1A	1 BEDROOM	58.20 m²	3.7m ²
114	1A	1 BEDROOM	58.20 m²	3.7m ²
115	2C	2 BEDROOM	88.89 m²	4m ²
116	2D	2 BEDROOM	104.63 m²	4m ²
117	2E	2 BEDROOM	92.78 m²	4m ²
201	2B	2 BEDROOM	76.41 m²	4m ²
202	2A	2 BEDROOM	86.85 m²	4m ²
203	2A	2 BEDROOM	86.85 m²	4m ²
204	2A	2 BEDROOM	86.85 m²	4m ²
205	2A	2 BEDROOM	86.85 m²	4m ²
206	2A	2 BEDROOM	86.85 m²	4m ²
207	2C	2 BEDROOM	88.89 m²	4m ²
208	2C	2 BEDROOM	88.89 m²	4m ²
209	1A	1 BEDROOM	58.20 m²	3.7m ²
210	1A	1 BEDROOM	58.20 m²	3.7m ²
211	1A	1 BEDROOM	58.20 m²	3.7m ²
212	1A	1 BEDROOM	58.20 m²	3.7m ²
213	1A	1 BEDROOM	58.20 m²	3.7m ²
214	1A	1 BEDROOM	58.20 m²	3.7m ²
215	2C	2 BEDROOM	88.89 m²	4m ²
216	2D	2 BEDROOM	104.63 m²	4m ²
217	2E	2 BEDROOM	92.78 m²	4m ²
301	2B	2 BEDROOM	76.41 m²	4m ²
302	2A	2 BEDROOM	86.85 m²	4m ²
303	2A	2 BEDROOM	86.85 m²	4m ²
304	2A	2 BEDROOM	86.85 m²	4m ²
305	2A	2 BEDROOM	86.85 m²	4m ²
306	2A	2 BEDROOM	86.85 m²	4m ²
307	2C	2 BEDROOM	88.89 m²	4m ²
308	2C	2 BEDROOM	88.89 m²	4m ²
309	1A	1 BEDROOM	58.20 m²	3.7m ²
310	1A	1 BEDROOM	58.20 m²	3.7m ²
311	1A	1 BEDROOM	58.20 m²	3.7m ²
312	1A	1 BEDROOM	58.20 m²	3.7m ²
313	1A	1 BEDROOM	58.20 m²	3.7m ²
314	1A	1 BEDROOM	58.20 m²	3.7m ²
315	2C	2 BEDROOM	88.89 m²	4m ²
316	2D	2 BEDROOM	104.63 m²	4m ²
317	2E	2 BEDROOM	92.78 m²	4m ²

APARTMENT SCH.				
APT. No.	APT. TYPE	APT. FUNCTION	APT. AREA	APT. STORE
401	3B	3 BEDROOM	129.43 m²	4m ²
402	3B	3 BEDROOM	129.43 m²	4m ²
403	3B	3 BEDROOM	129.43 m²	4m ²
404	3B	3 BEDROOM	129.43 m²	4m ²
405	3B	3 BEDROOM	129.43 m²	4m ²
406	3B	3 BEDROOM	129.43 m²	4m ²
407	3A	3 BEDROOM	132.61 m²	5m ²
408	3A	3 BEDROOM	132.61 m²	5m ²
409	2F	2 BEDROOM	95.92 m²	4m ²
410	2F	2 BEDROOM	95.92 m²	4.3m ²
411	2F	2 BEDROOM	95.92 m²	4.3m ²
412	2F	2 BEDROOM	95.92 m²	4.3m ²
413	2F	2 BEDROOM	95.92 m²	5.8m ²
414	2F	2 BEDROOM	95.92 m²	5.8m ²
415	3A	3 BEDROOM	133.63 m²	5m ²
416	3A	3 BEDROOM	136.47 m²	5m ²
417	3A	3 BEDROOM	133.65 m²	5m ²
TOTAL APARTMENT AREA			5992.91 m²	

COMMERCIAL AREA	
TENANCY 01	178.7m²
TENANCY 02	137.6m²
TENANCY 03	106.2m²
TOTAL GFA	422.5m²

©architectus™

Architectus Australia Pty Ltd is the owner of the copyright subsisting in these drawings, plans, designs and specifications. They must not be used, reproduced or copied, in whole or in part, nor may the information, ideas and concepts therein contained (which are confidential to Architectus Australia Pty Ltd) be disclosed to any person without the prior written consent of that company.

Nominated Architect
Ray Brown, NSWARB 6359

Do not scale drawings. Verify all dimensions on site

issue	amendment	date
A	DA SUBMISSION	25/03/2021

DEPARTMENT OF PLANNING, LANDS AND HERITAGE	
DATE 07-Apr-2021	FILE SDAU-007-20

architectus™

Adelaide
Brisbane
Melbourne
Sydney
Perth

Architectus Perth
QV1 Upper Plaza West
250 St. Georges Terrace
Perth WA 6000
T (61 8) 9412 8355

perth@architectus.com.au
ABN 90 131 245 684

checked
drawn
scale

Checker
Author
1 : 100@A3

project 10 MORLEY DRIVE, TUART HILL


drawing

APARTMENT SCHEDULE

project no 200611
issue

drawing no. DA4015 A

26/03/2021 12:23:05 PM

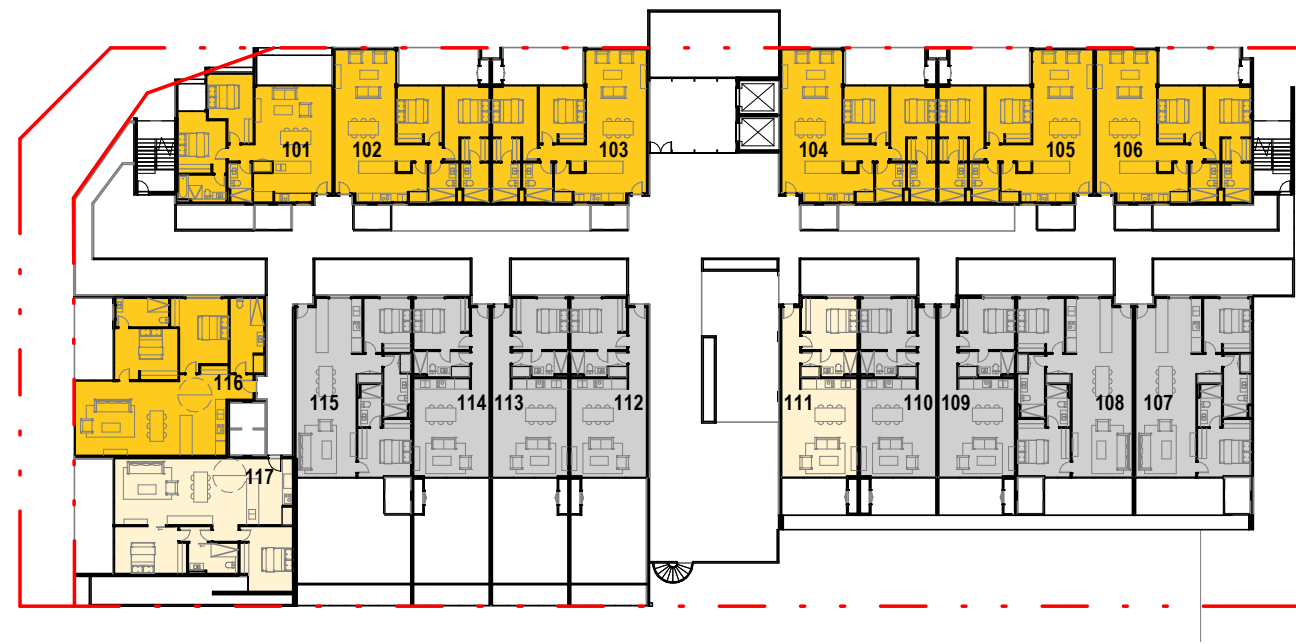


1 DAYLIGHT ACCESS - L01
SCALE: 1:500




2 DAYLIGHT ACCESS - L02
SCALE: 1:500

DEPARTMENT OF PLANNING, LANDS
AND HERITAGE

DATE	FILE
07-Apr-2021	SDAU-007-20

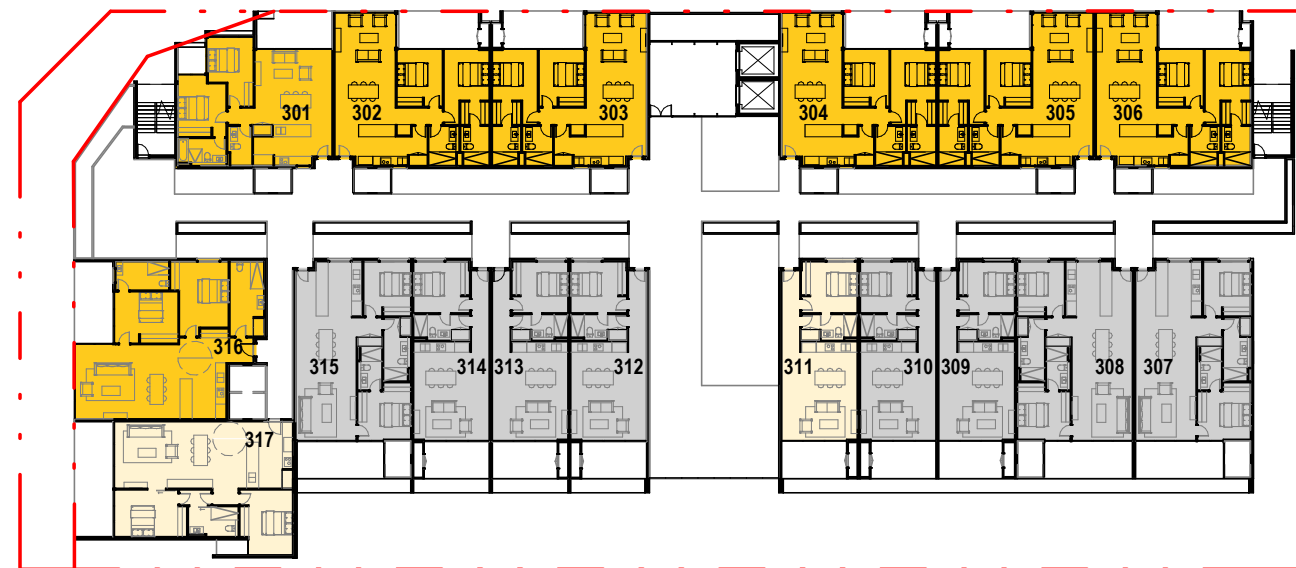

3 DAYLIGHT ACCESS - L03
SCALE: 1:500

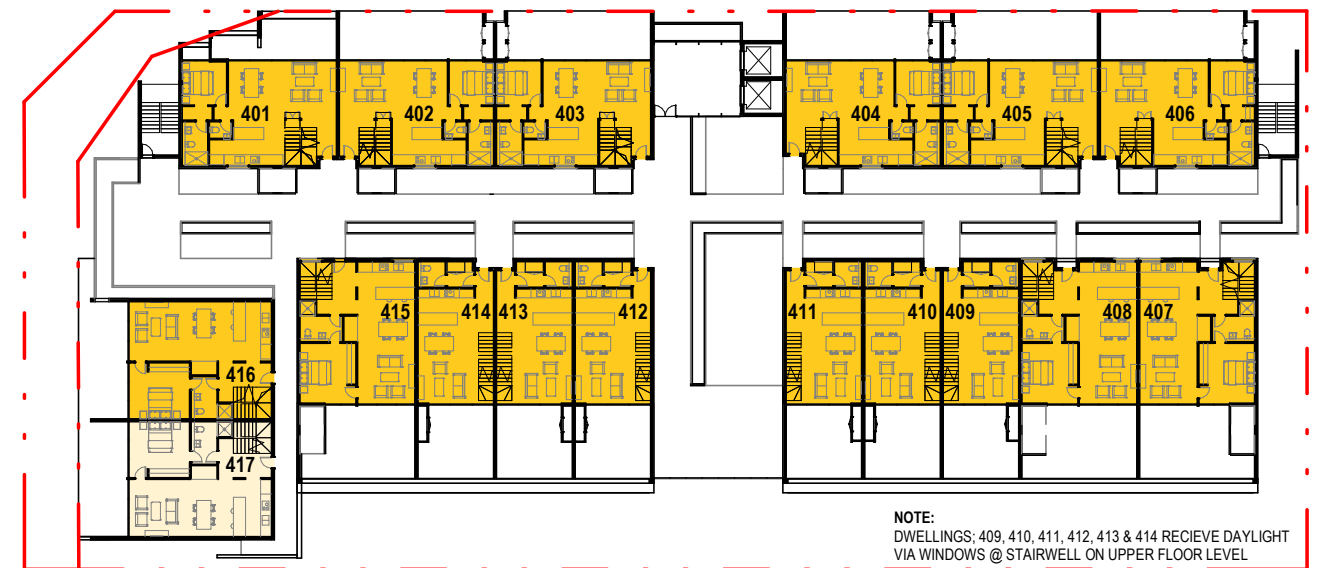

NOTE:
DWELLINGS: 409, 410, 411, 412, 413 & 414 RECEIVE DAYLIGHT
VIA WINDOWS @ STAIRWELL ON UPPER FLOOR LEVEL

4 DAYLIGHT ACCESS - L04
SCALE: 1:500


©architectus™

Architectus Australia Pty Ltd is the owner of the copyright subsisting in these drawings, plans, designs and specifications. They must not be used, reproduced or copied, in whole or in part, nor may the information, ideas and concepts therein contained (which are confidential to Architectus Australia Pty Ltd) be disclosed to any person without the prior written consent of that company.

Nominated Architect
Ray Brown, NSWARB 6359

Do not scale drawings. Verify all dimensions on site

issue	amendment	date
A	DA SUBMISSION	25/03/2021

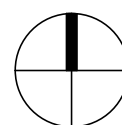

DAYLIGHT LEGEND		
KEY	#	%
DWELLINGS THAT WILL HAVE ACCESS TO A MIN. OF 2 HOURS OF DIRECT SUNLIGHT BETWEEN 9am & 3pm ON 21 JUNE	37	55%
DWELLINGS THAT WILL RECEIVE LESS THAN 2 HOURS OF DIRECT SUNLIGHT BETWEEN 9am & 3pm ON 21 JUNE	7	10%
DWELLINGS THAT WILL NOT RECEIVE ANY DIRECT SUNLIGHT BETWEEN 9am & 3pm ON 21 JUNE	24	35%

architectus™

Adelaide
Brisbane
Melbourne
Sydney
Perth

checked
drawn
scale

Architectus Perth
QV1 Upper Plaza West
250 St. Georges Terrace
Perth WA 6000
T (61 8) 9412 8355
perth@architectus.com.au
ABN 90 131 245 684

AS
FMK
A3
1:500 @


project 10 MORLEY DRIVE, TUART HILL

drawing DAYLIGHT ACCESS


project no. 200611

drawing no. DA4020 issue A

26/03/2021 12:23:33 PM

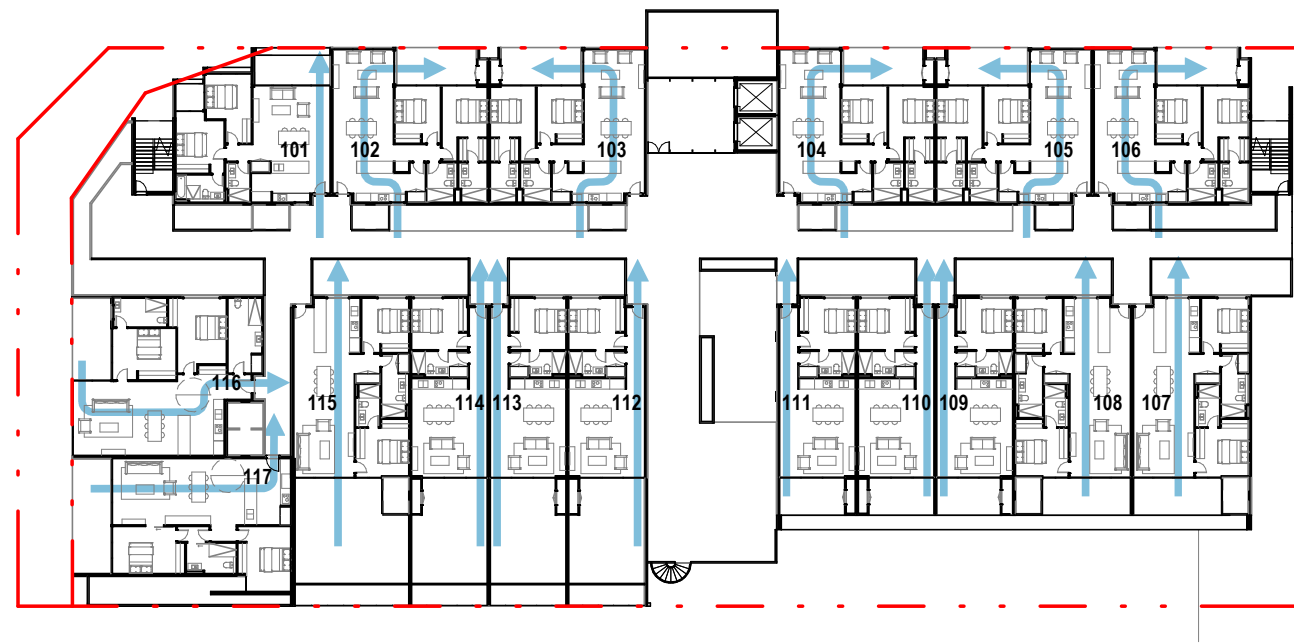


1 CROSS VENTILATION - L01
SCALE: 1:500

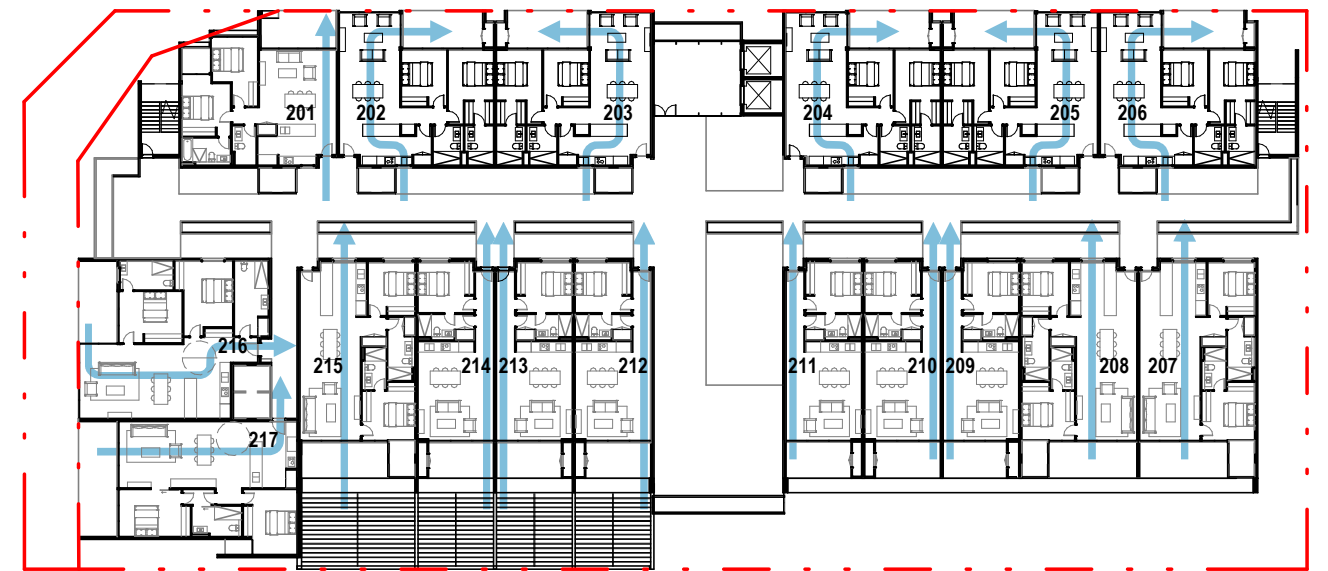

2 CROSS VENTILATION - L02-L03 TYPICAL
SCALE: 1:500

CROSS VENTILATION LEGEND		
	CROSS VENTILATION PATH	
NUMBER OF APARTMENTS WITH CROSS VENTILATION	68	100%

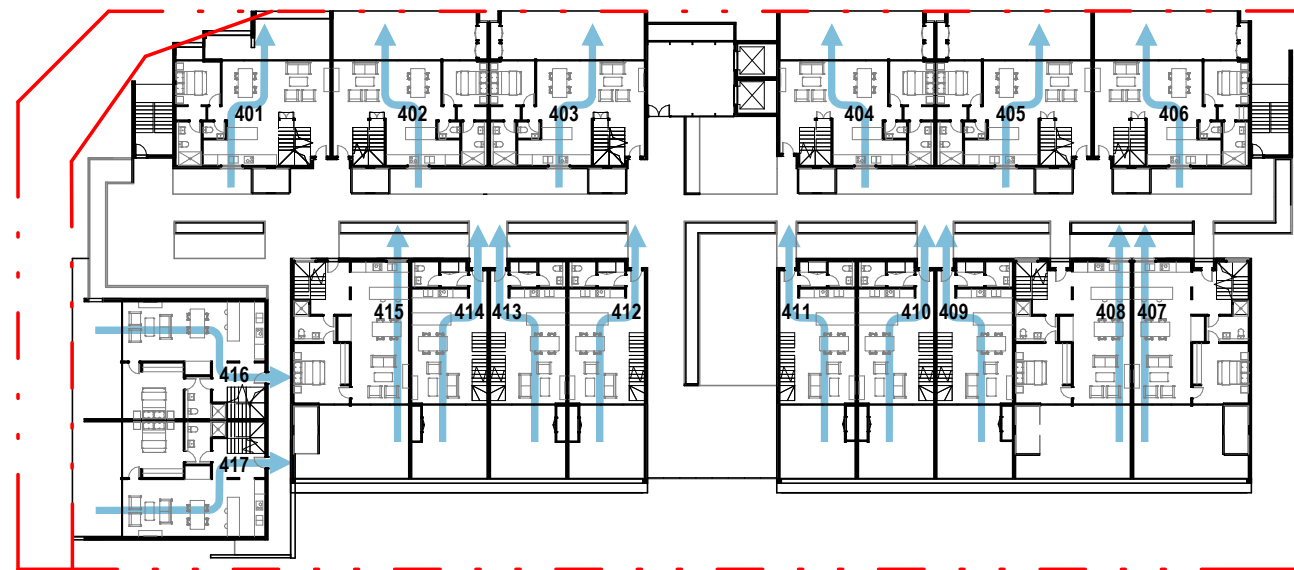

3 CROSS VENTILATION - L04
SCALE: 1:500


©architectus™

Architectus Australia Pty Ltd is the owner of the copyright subsisting in these drawings, plans, designs and specifications. They must not be used, reproduced or copied, in whole or in part, nor may the information, ideas and concepts therein contained (which are confidential to Architectus Australia Pty Ltd) be disclosed to any person without the prior written consent of that company.

Nominated Architect
Ray Brown, NSWARB 6359

Do not scale drawings. Verify all dimensions on site

issue	amendment	date
A	DA SUBMISSION	25/03/2021

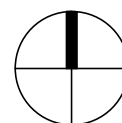

DEPARTMENT OF PLANNING, LANDS AND HERITAGE	
DATE	FILE
07-Apr-2021	SDAU-007-20

architectus™

Adelaide
Brisbane
Melbourne
Sydney
Perth

Architectus Perth
QV1 Upper Plaza West
250 St. Georges Terrace
Perth WA 6000
T (61 8) 9412 8355

perth@architectus.com.au
ABN 90 131 245 684

checked AS
drawn FMK
scale 1:500 @ A3

project 10 MORLEY DRIVE, TUART HILL

drawing


CROSS VENTILATION

project no 200611


issue

drawing no. DA4030 A

26/03/2021 12:23:57 PM

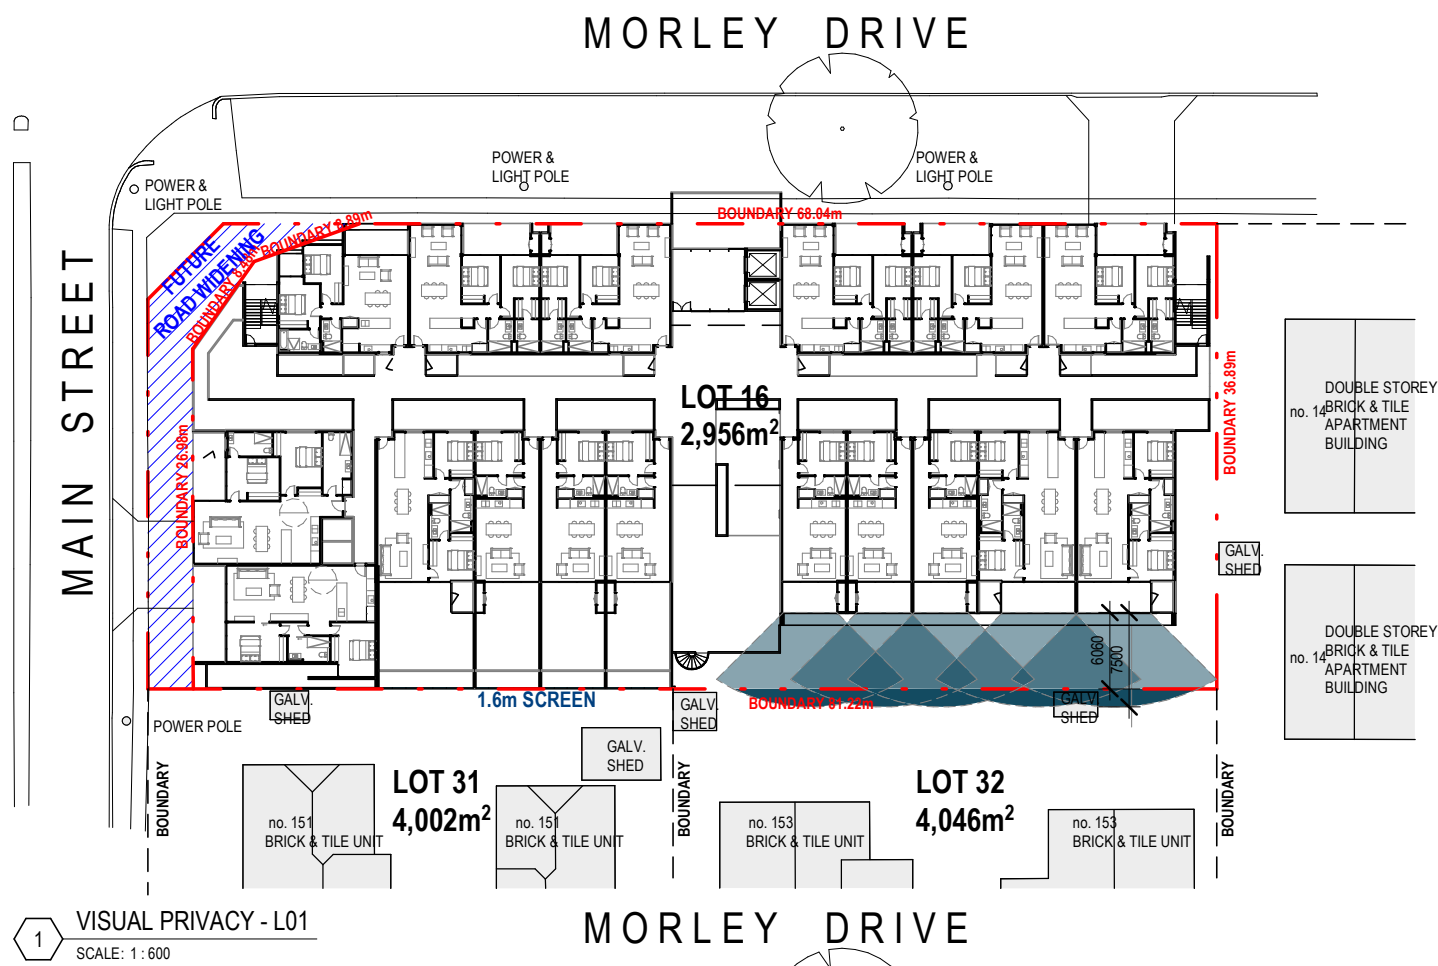

1 VISUAL PRIVACY - L01
SCALE: 1:600

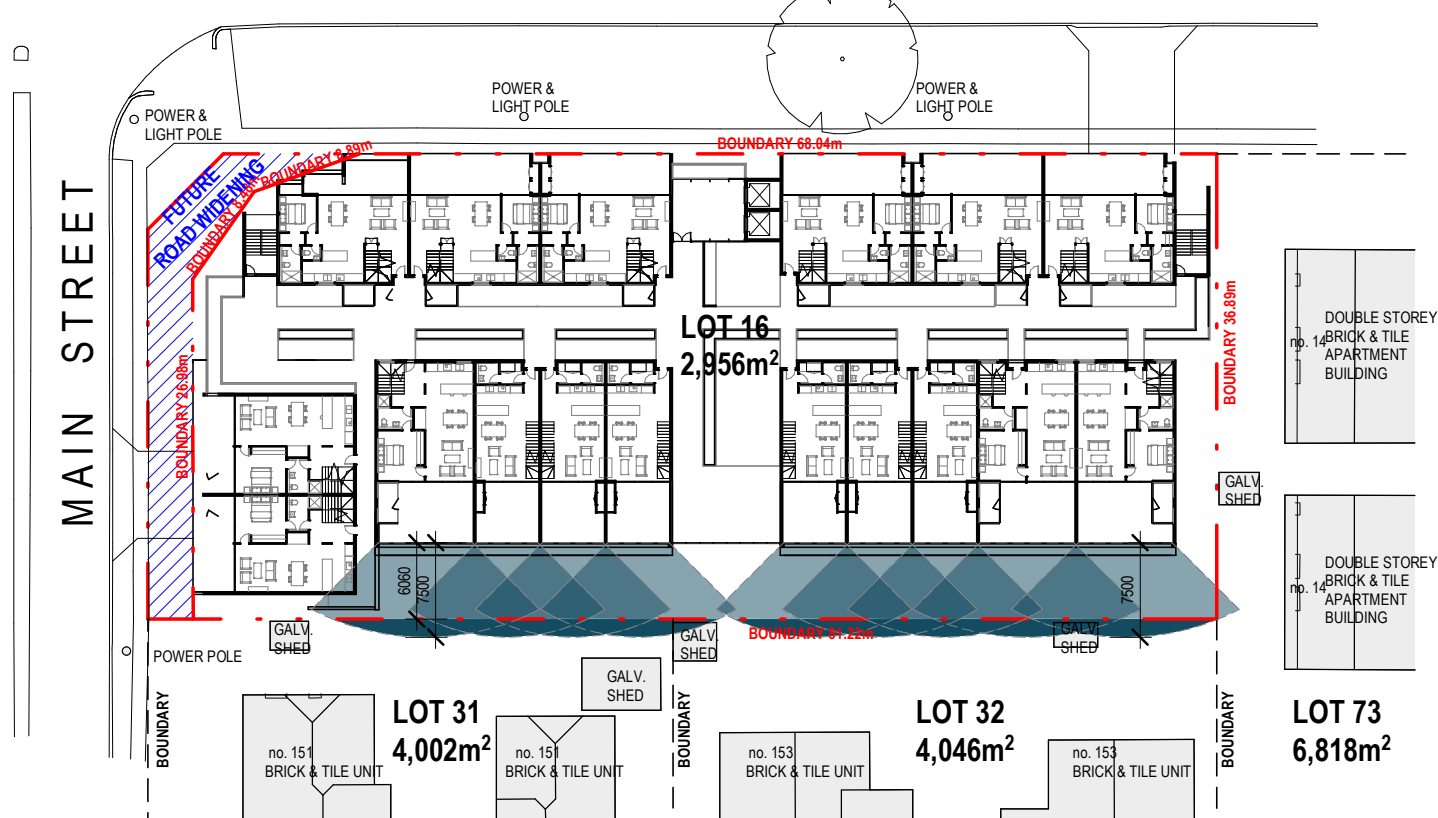

3 VISUAL PRIVACY - L04
SCALE: 1:600


© architectus™

Architectus Australia Pty Ltd is the owner of the copyright subsisting in these drawings, plans, designs and specifications. They must not be used, reproduced or copied, in whole or in part, nor may the information, ideas and concepts therein contained (which are confidential to Architectus Australia Pty Ltd) be disclosed to any person without the prior written consent of that company.


Nominated Architect
Ray Brown, NSWARB 6359

Do not scale drawings. Verify all dimensions on site


issue	amendment	date
A	DA SUBMISSION	25/03/2021

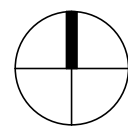

DEPARTMENT OF PLANNING, LANDS AND HERITAGE	
DATE	FILE
07-Apr-2021	SDAU-007-20

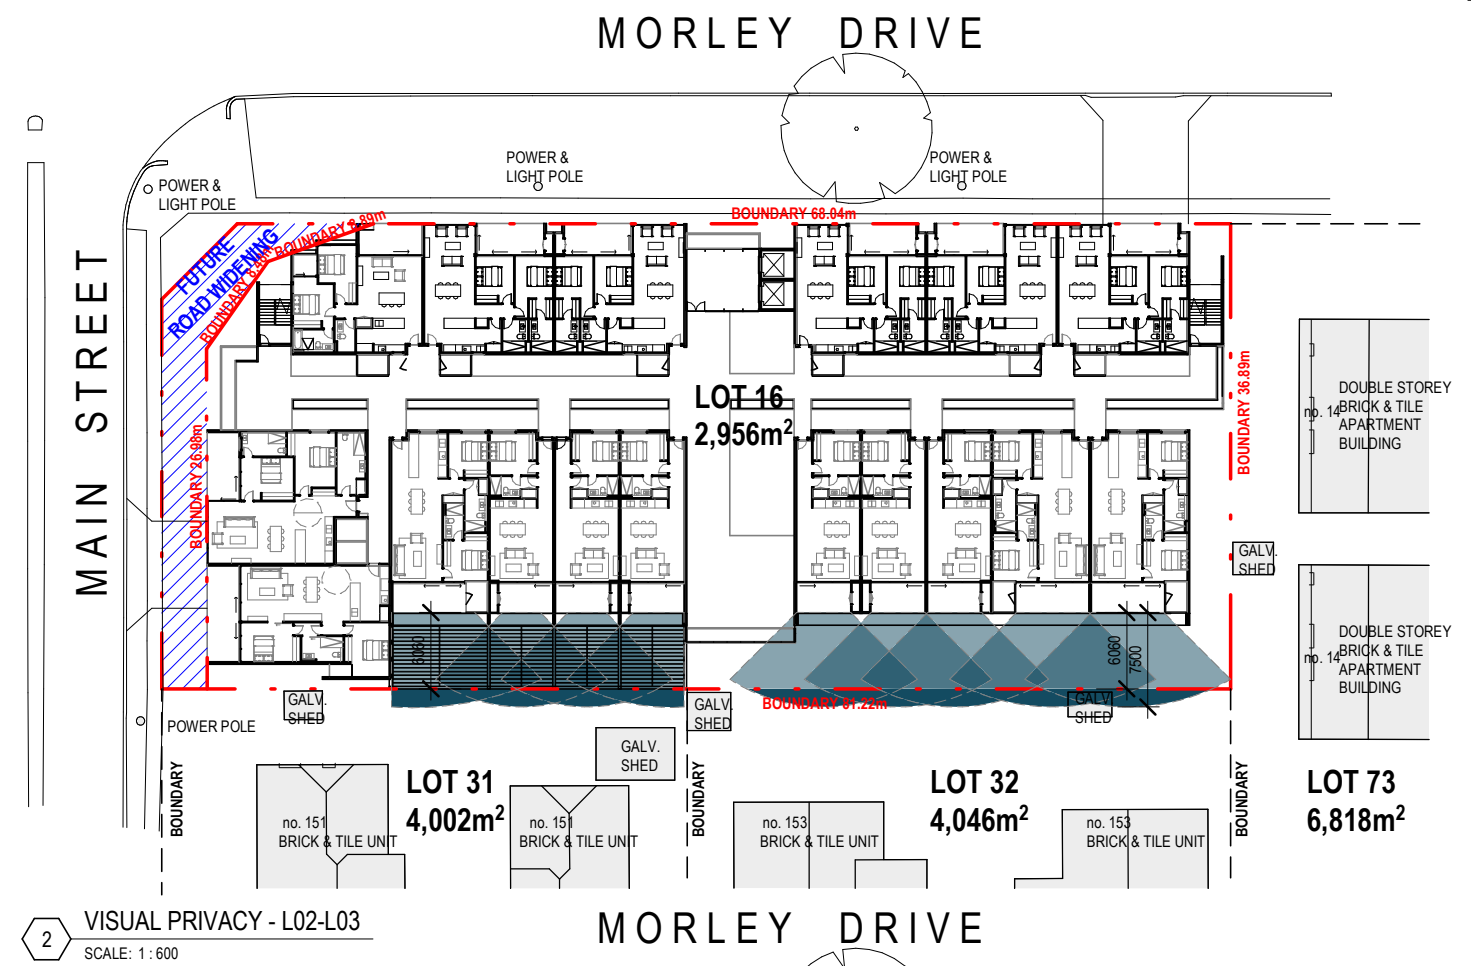

2 VISUAL PRIVACY - L02-L03
SCALE: 1:600

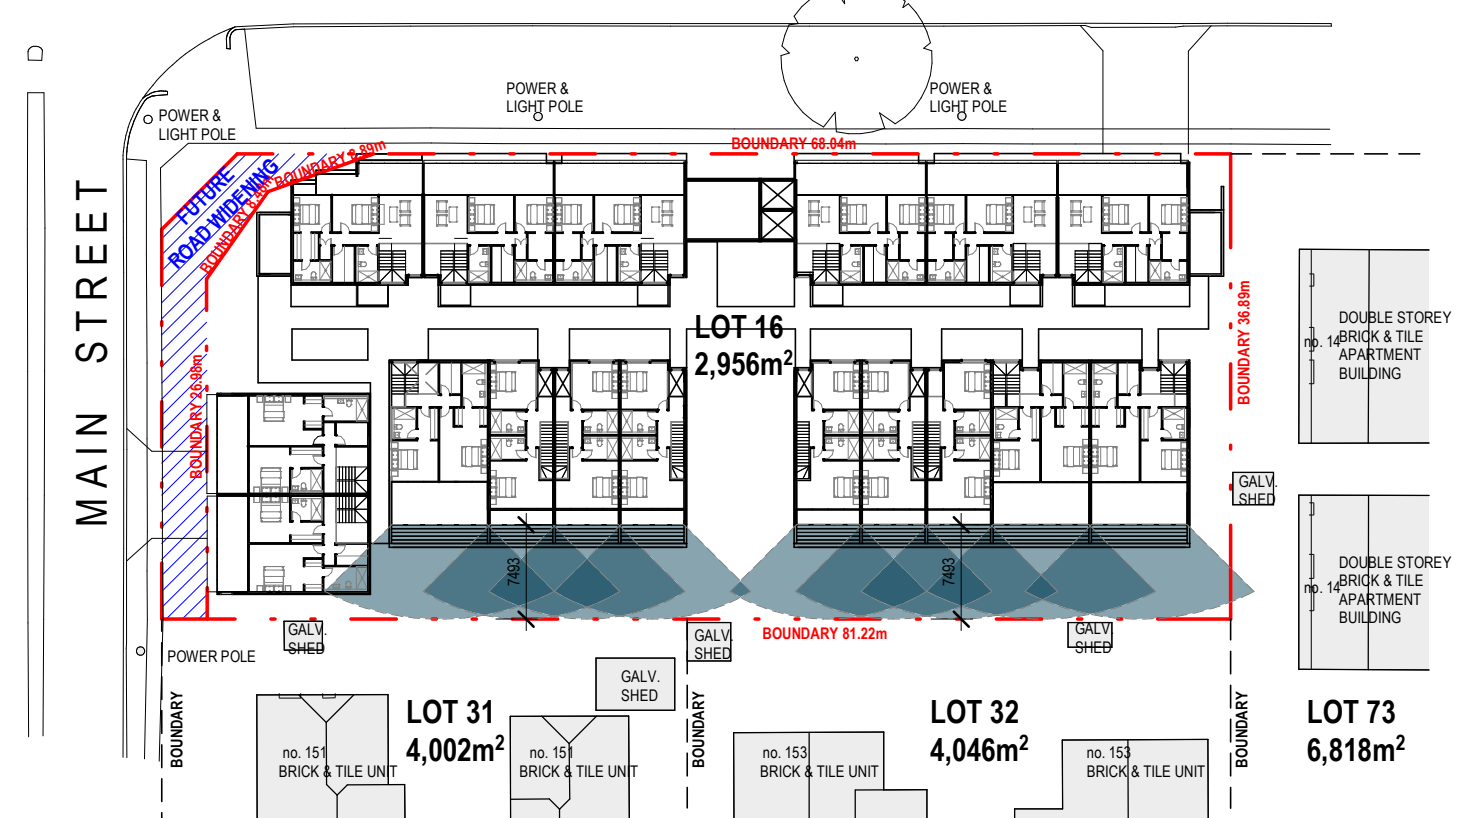

4 VISUAL PRIVACY - L05
SCALE: 1:600

architectus™

Adelaide
Brisbane
Melbourne
Sydney
Perth

checked
drawn
scale

Architectus Perth
QV1 Upper Plaza West
250 St. Georges Terrace
Perth WA 6000
T (61 8) 9412 8355

perth@architectus.com.au
ABN 90 131 245 684

AS
FMK
A3
1:600 @

project 10 MORLEY DRIVE, TUART HILL

drawing

VISUAL PRIVACY

project no 200611

issue A

drawing no. DA4040

26/03/2021 12:24:27 PM



SITE CONTEXT - LOOKING EAST



SITE CONTEXT - LOOKING WEST



SITE CONTEXT - LOOKING NORTH



SITE CONTEXT - LOOKING SOUTH

©architectus™

Architectus Australia Pty Ltd is the owner of the copyright subsisting in these drawings, plans, designs and specifications. They must not be used, reproduced or copied, in whole or in part, nor may the information, ideas and concepts therein contained (which are confidential to Architectus Australia Pty Ltd) be disclosed to any person without the prior written consent of that company.

Nominated Architect
Ray Brown, NSWARB 6359

Do not scale drawings. Verify all dimensions on site

issue	amendment	date
A	DA SUBMISSION	25/03/2021

DEPARTMENT OF PLANNING, LANDS AND HERITAGE	
DATE	FILE
07-Apr-2021	SDAU-007-20

architectus™

Adelaide
Brisbane
Melbourne
Sydney
Perth

checked
drawn
scale

Architectus Perth
QV1 Upper Plaza West
250 St. Georges Terrace
Perth WA 6000
T (61 8) 9412 8355

perth@architectus.com.au
ABN 90 131 245 684

AS
FMK
@A3

project	10 MORLEY DRIVE, TUART HILL		
drawing	EXISTING STREET CONTEXT		
project no		200611	
		issue	
drawing no.	DA4050		A
26/03/2021 12:24:35 PM			



SITE CONTEXT - LOOKING EAST



SITE CONTEXT - LOOKING WEST



SITE CONTEXT - LOOKING NORTH



SITE CONTEXT - LOOKING SOUTH

©architectus™

Architectus Australia Pty Ltd is the owner of the copyright subsisting in these drawings, plans, designs and specifications. They must not be used, reproduced or copied, in whole or in part, nor may the information, ideas and concepts therein contained (which are confidential to Architectus Australia Pty Ltd) be disclosed to any person without the prior written consent of that company.

Nominated Architect
Ray Brown, NSWARB 6359

Do not scale drawings. Verify all dimensions on site

issue	amendment	date
A	DA SUBMISSION	25/03/2021

DEPARTMENT OF PLANNING, LANDS AND HERITAGE	
DATE	FILE
07-Apr-2021	SDAU-007-20

architectus™

Adelaide
Brisbane
Melbourne
Sydney
Perth

checked
drawn
scale

Architectus Perth
QV1 Upper Plaza West
250 St. Georges Terrace
Perth WA 6000
T (61 8) 9412 8355
perth@architectus.com.au
ABN 90 131 245 684

Checker
Author
@A3


project	10 MORLEY DRIVE, TUART HILL		
drawing	STREET CONTEXT		
project no	200611	issue	
drawing no.	DA4051		A
26/03/2021 12:24:41 PM			




L02 VIEW ACROSS ATRIUM



L02 VIEW ACROSS ATRIUM

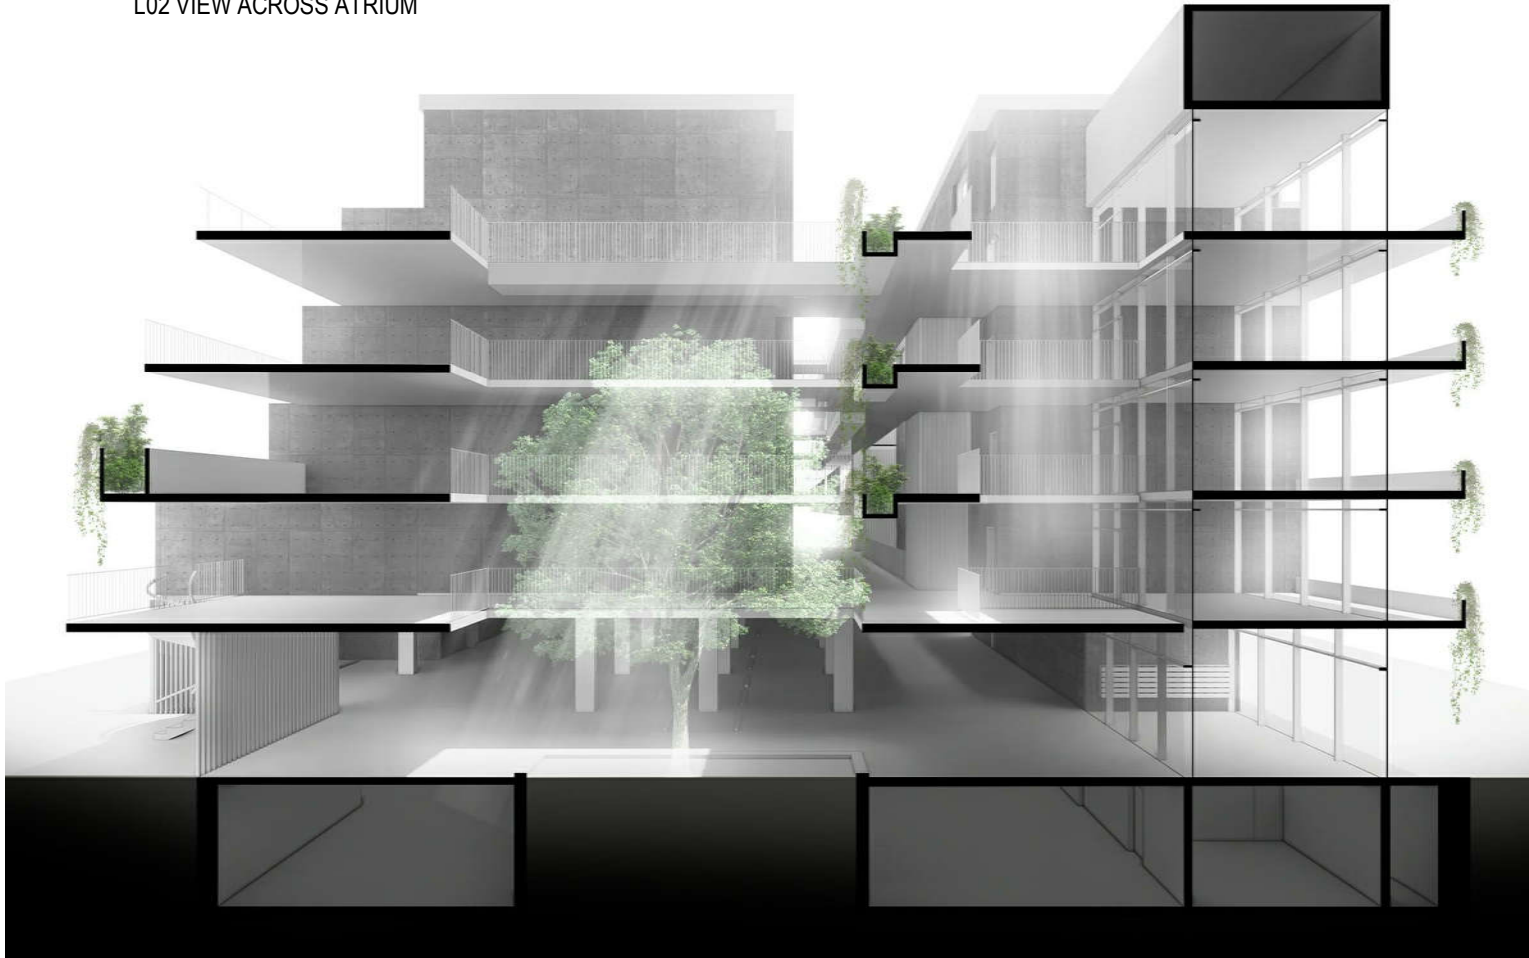

SECTIONAL PERSPECTIVE THRU ATRIUM

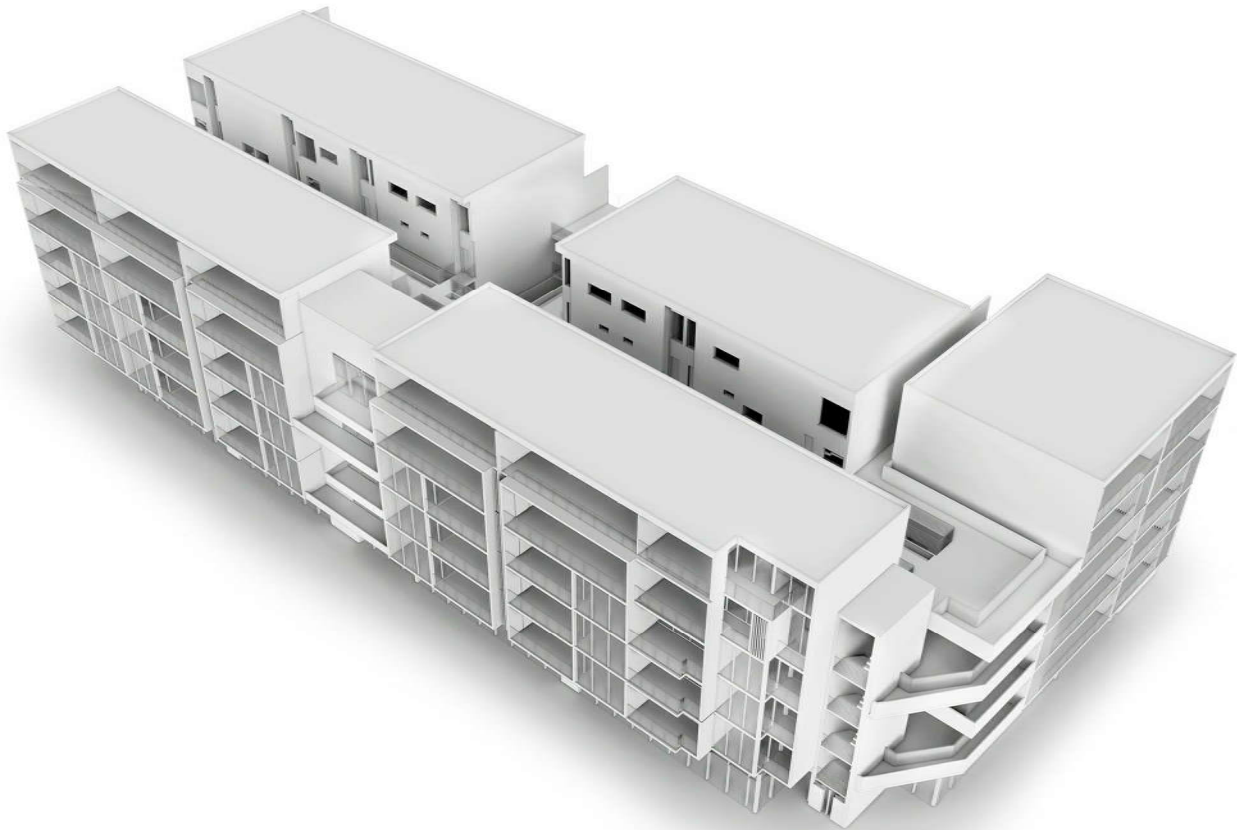

AXONOMETRIC VIEW

©architectus™

Architectus Australia Pty Ltd is the owner of the copyright subsisting in these drawings, plans, designs and specifications. They must not be used, reproduced or copied, in whole or in part, nor may the information, ideas and concepts therein contained (which are confidential to Architectus Australia Pty Ltd) be disclosed to any person without the prior written consent of that company.

Nominated Architect
Ray Brown, NSWARB 6359

Do not scale drawings. Verify all dimensions on site

issue	amendment	date
A	DA SUBMISSION	25/03/2021

DEPARTMENT OF PLANNING, LANDS AND HERITAGE	
DATE	FILE
07-Apr-2021	SDAU-007-20

architectus™

Adelaide
Brisbane
Melbourne
Sydney
Perth

checked
drawn
scale

Architectus Perth
QV1 Upper Plaza West
250 St. Georges Terrace
Perth WA 6000
T (61 8) 9412 8355

perth@architectus.com.au
ABN 90 131 245 684

AS
FMK
@A3

project 10 MORLEY DRIVE, TUART HILL

drawing ARCHITECTURAL VIGNETTES

project no 200611
issue

drawing no. DA4060 A

26/03/2021 12:24:46 PM



©architectus™

Architectus Australia Pty Ltd is the owner of the copyright subsisting in these drawings, plans, designs and specifications. They must not be used, reproduced or copied, in whole or in part, nor may the information, ideas and concepts therein contained (which are confidential to Architectus Australia Pty Ltd) be disclosed to any person without the prior written consent of that company.

Nominated Architect
Ray Brown, NSWARB 6359

Do not scale drawings. Verify all dimensions on site

issue	amendment	date
A	DA SUBMISSION	25/03/2021

DEPARTMENT OF PLANNING, LANDS AND HERITAGE	
DATE	FILE
07-Apr-2021	SDAU-007-20

architectus™

Adelaide
Brisbane
Melbourne
Sydney
Perth

Architectus Perth
QV1 Upper Plaza West
250 St. Georges Terrace
Perth WA 6000
T (61 8) 9412 8355

perth@architectus.com.au
ABN 90 131 245 684

checked
drawn
scale

Checker
Author
@A3

project	10 MORLEY DRIVE, TUART HILL		
drawing	EXTERNAL RENDER		
project no			200611
drawing no.	DA4070	issue	A
26/03/2021 12:24:52 PM			



©architectus™

Architectus Australia Pty Ltd is the owner of the copyright subsisting in these drawings, plans, designs and specifications. They must not be used, reproduced or copied, in whole or in part, nor may the information, ideas and concepts therein contained (which are confidential to Architectus Australia Pty Ltd) be disclosed to any person without the prior written consent of that company.

Nominated Architect
Ray Brown, NSWARB 6359

Do not scale drawings. Verify all dimensions on site

issue	amendment	date
A	DA SUBMISSION	25/03/2021



architectus™

Adelaide
Brisbane
Melbourne
Sydney
Perth

Architectus Perth
QV1 Upper Plaza West
250 St. Georges Terrace
Perth WA 6000
T (61 8) 9412 8355

perth@architectus.com.au
ABN 90 131 245 684

checked
drawn
scale

Checker
Author
@A3

project	10 MORLEY DRIVE, TUART HILL
drawing	INTERNAL RENDER
project no	200611
drawing no.	DA4071
issue	A
26/03/2021 12:24:57 PM	